



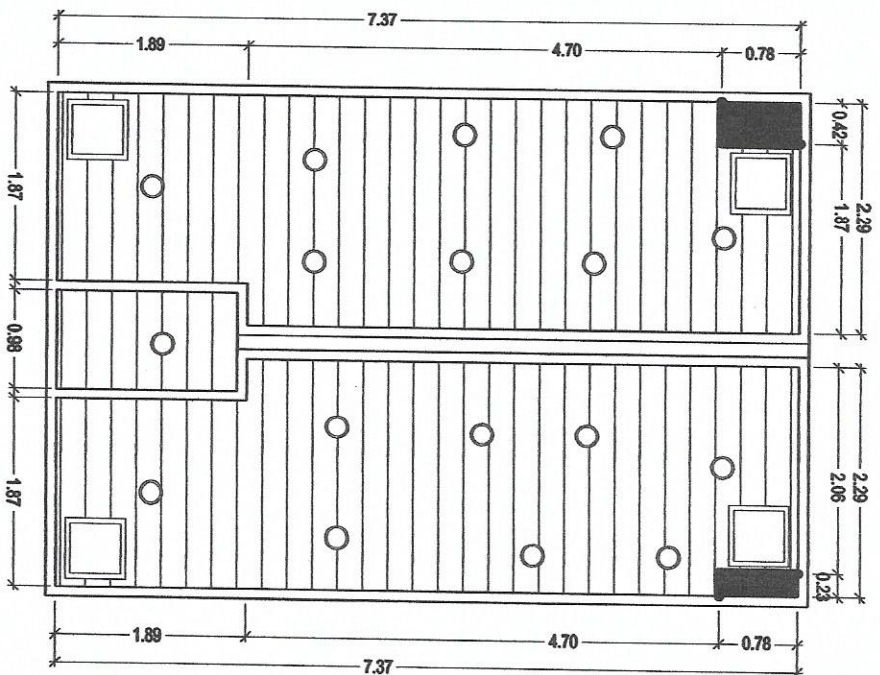

GROUND FLOOR LEFT WING
PUBLIC COMFORT ROOM

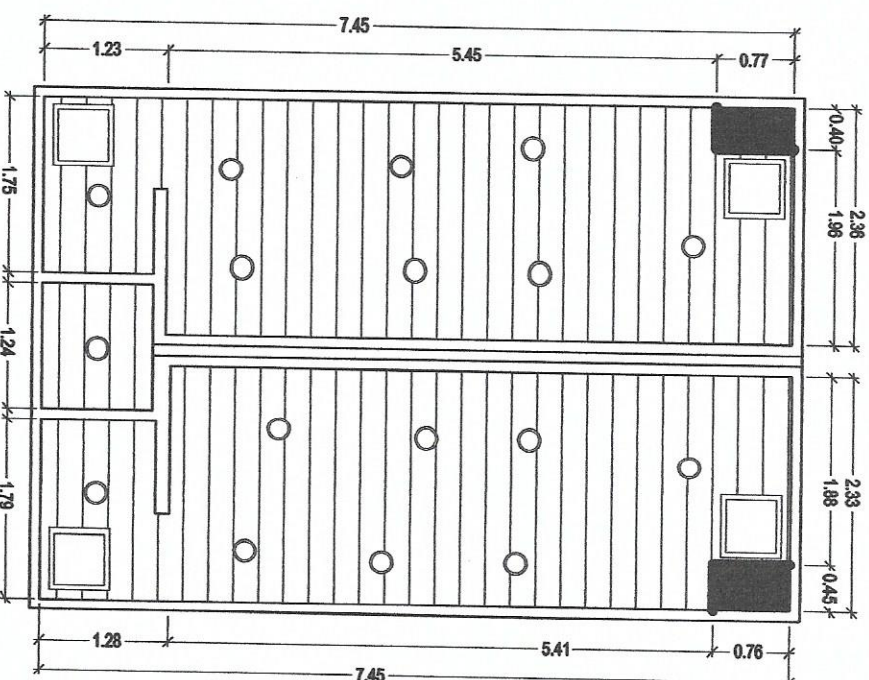

GROUND FLOOR RIGHT WING
PUBLIC COMFORT ROOM

1
SCALE

REFLECTED CEILING PLAN (NART BLDG. - GROUND FLOOR)

1:75 MTS



Republic of the Philippines
DEPARTMENT OF SCIENCE AND TECHNOLOGY
PHILIPPINE NUCLEAR RESEARCH INSTITUTE
CARMONAVECIN, ANTONIO DIASIN, CAGAYAN CITY

PROJECT
UPGRADING OF
N.A.R.T. BLDG.
(C.Y. 2020)

OWNER
PHILIPPINE NUCLEAR
RESEARCH INSTITUTE

SHEET CONTENT
REFLECTED CEILING PLAN
OF PUBLIC COMFORT
ROOM - GROUND FLOOR
NART BLDG.

PREPARED BY

ENGR. ROSALINDA B. REYES
Senior Engineer
Structural Engineering Division

RECOMMENDING APPROVAL

ENGR. VILLANUEVA
Head GSE
ENGR. BENITO T. BANGA
Head GSE
ENGR. CELERIO M. RAMIRO
Chief
PREOCSAB PARRERA, Ph.D.
Head GSE
SOLEDAD S. CASTANEDA, Ph.D.
Design Director

APPROVED BY

ARICIA A. ARICIA, Ph.D.
Director

DRAWN BY: GENBAYCO

CHECKED BY:

DATE: FEB. 28, 2020

SHEET NO.:
A-11

PAGE NO.:
11/25



UPGRADING OF
N.A.R.T. BLDG.
(C.Y. 2020)

PHILIPPINES NUCLEAR
RESEARCH INSTITUTE

REFLECTED CEILING PLAN
OF PUBLIC COMFORT
ROOM - GROUND FLOOR
NART BLDG.

ESTR. ROSALINO B. REAS
Senior Scientist, Speech & Hearing
Estr. ARNOLD L. GALT
Senior Scientist, Research Scientist

RECORD ENDING APPROVAL

ANNA M. ILLANUEVA
Head, OSS

MA. CELERINA M. RAMIRO
Chief, P&E

ENG. RENZO T. BANGA
ESS Head

PRECIOSA PABABO, Ph. D.
Chief, MSD

SOLEDAD S. CASTANEDA, Ph. D.
Deputy Chief



CARLO A. ARCILLA, Ph. D.
Director

CHECKED BY:

DATE: FEB. 20, 2020

A-12

PAGE NO. : 12/25

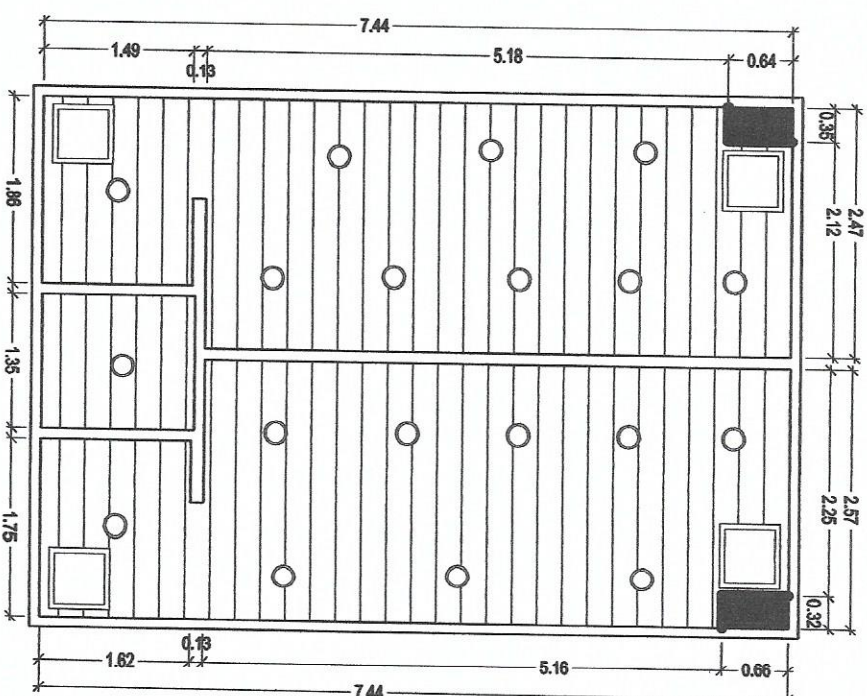
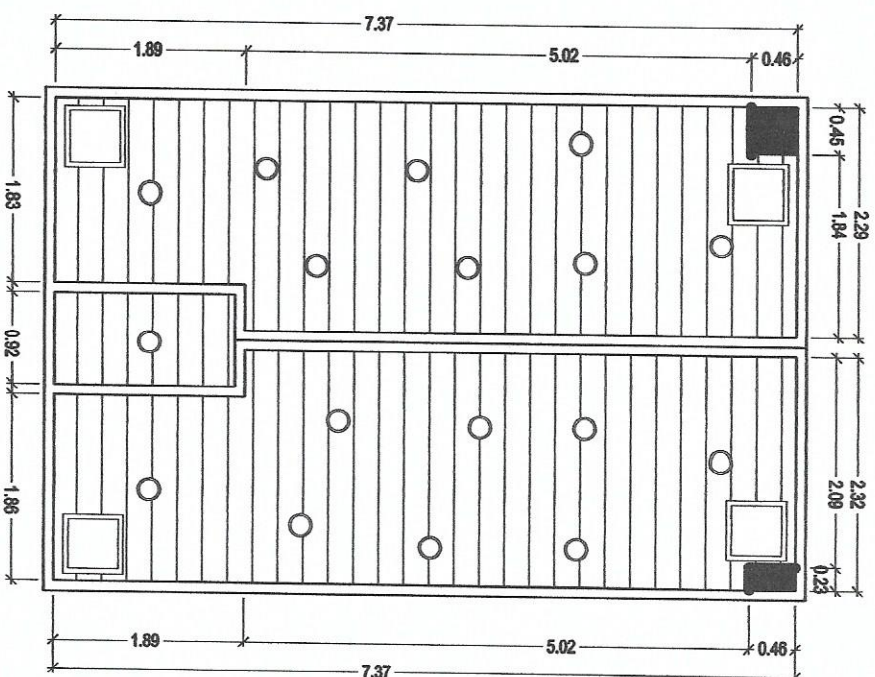


SECOND FLOOR LEFT WING
PUBLIC COMFORT ROOM

SECOND FLOOR RIGHT WING
PUBLIC COMFORT ROOM

1 REFLECTED CEILING PLAN (NART BLDG. - 2ND FLOOR)
SCALE 1:75 MTS

1:75 MTS

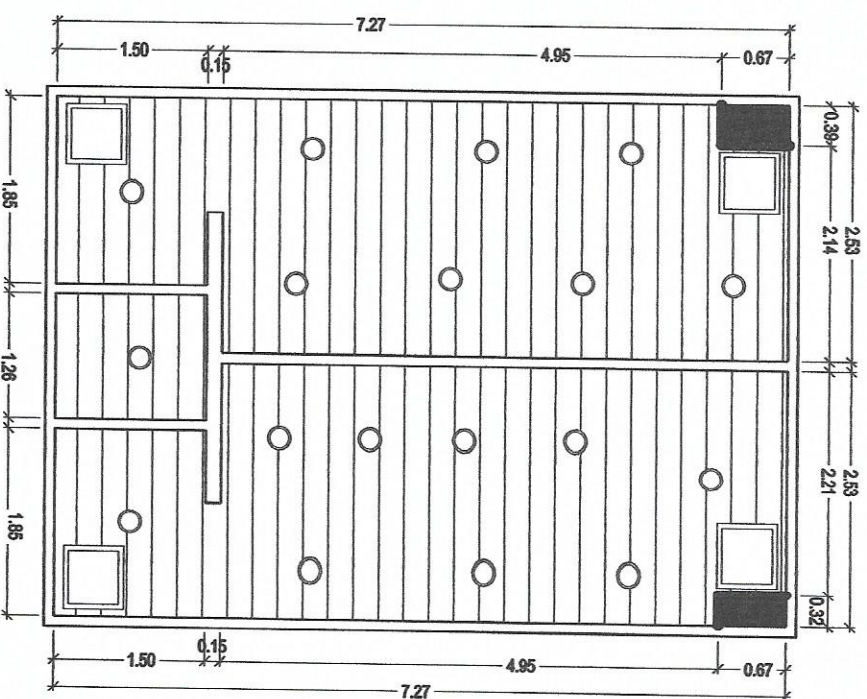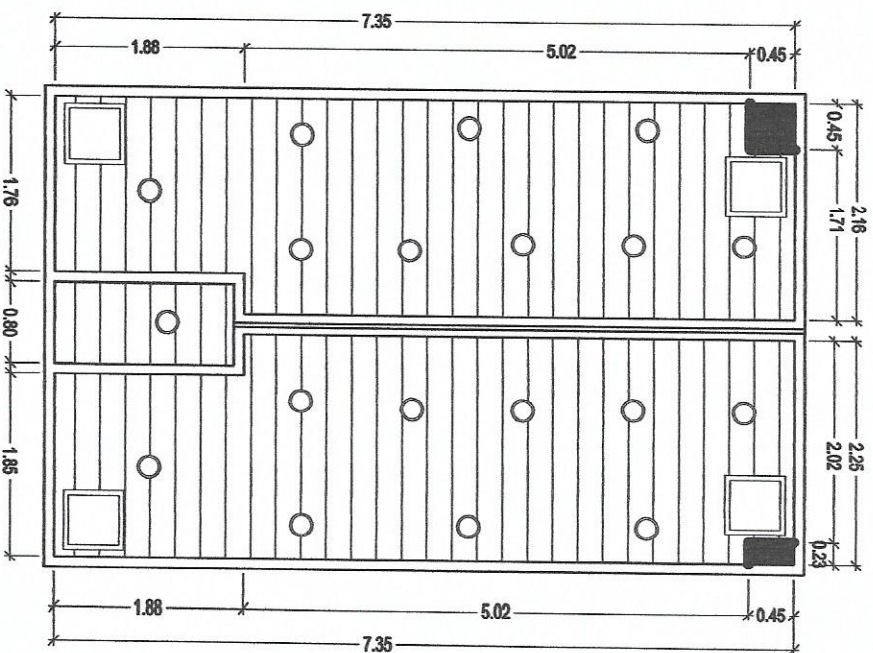


THIRD FLOOR LEFT WING
PUBLIC COMFORT ROOM


THIRD FLOOR RIGHT WING
PUBLIC COMFORT ROOM

1 REFLECTED CEILING PLAN (NART BLDG. - 3RD FLOOR)
SCALE 1:75 MTS

 Republic of the Philippines DEPARTMENT OF SCIENCE AND TECHNOLOGY PHILIPPINES NUCLEAR RESEARCH INSTITUTE COMMONWEALTH AVENUE, DILIMAN, QUEZON CITY		PROJECT: UPGRADING OF N.A.R.T. BLDG. (C.Y. 2020)	OWNER: PHILIPPINES NUCLEAR RESEARCH INSTITUTE	SHEET CONTENT: REFLECTED CEILING PLAN OF PUBLIC COMFORT ROOM - 3RD FLOOR NART BLDG.	PREPARED BY: Engr. ROSALIND B. REYES Senior Engineer (Interior Design) Engr. ARTHUR S. SALA Senior Engineer (Interior Design)	RECOMMENDATION APPROVAL: ANNETTE M. JUANAVEA Head of Office M. CELESTINA M. TORRES Chief of Office PRECIOUSAB. FRANCIS P. D. SOLEDAD S. CASTANEDA, Ph. D. Senior Director	APPROVED BY: CARLO A. ARCILLA, Ph. D. Director	DRAWN BY: GEBILAZO	CHECKED BY:	DATE: FEB 28 2020	SHEET NO.: A-13	MOJ. NO.: 13/25
---	--	---	---	---	---	---	--	--------------------	-------------	-------------------	--------------------	--------------------

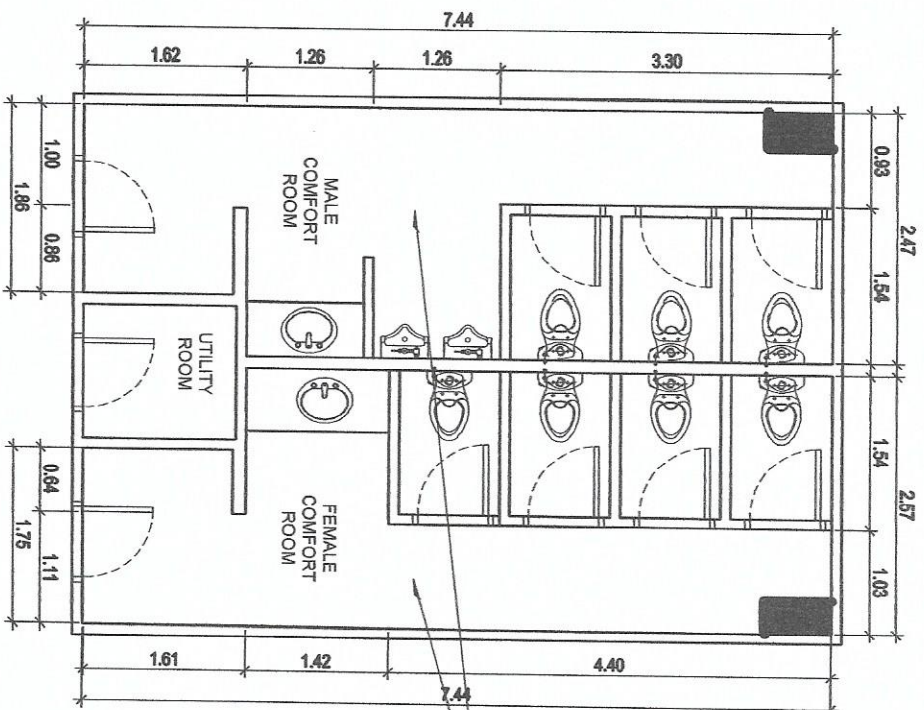

SECOND FLOOR RIGHT WING
PUBLIC COMFORT ROOM

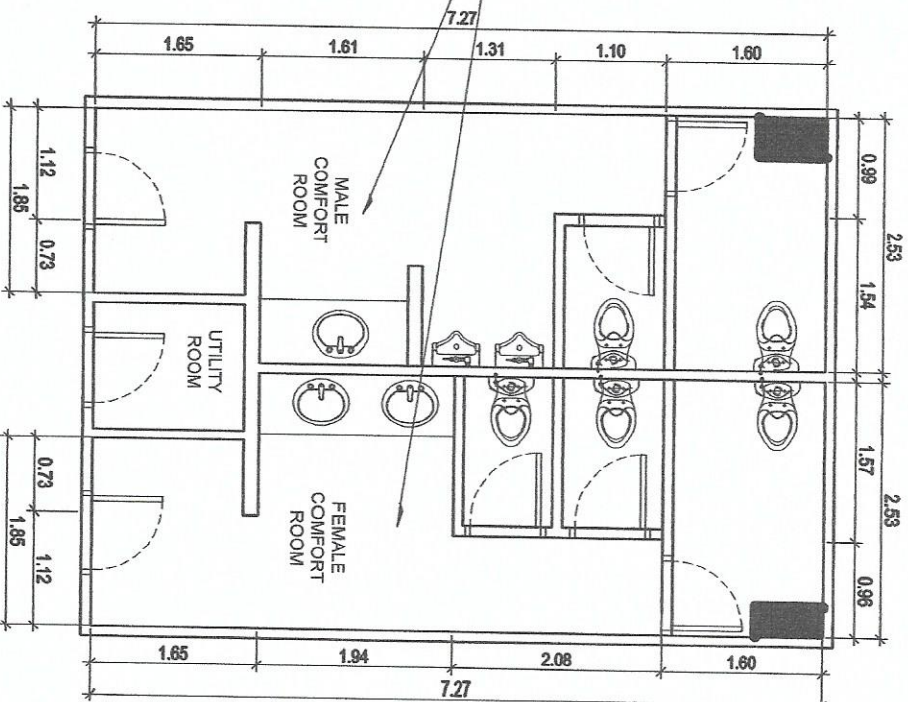


THIRD FLOOR RIGHT WING
PUBLIC COMFORT ROOM

1 PUBLIC COMFORT ROOM
SCALE 1:80 MTS



Republic of the Philippines
DEPARTMENT OF SCIENCE AND TECHNOLOGY
PHILIPPINE NUCLEAR RESEARCH INSTITUTE
COMMONWEALTH AVENUE, DAVAO CITY

PROJECT	OWNER	SHEET CONTENT	PREPARED BY	RECOMMENDING APPROVAL	APPROVED BY	DRAWN BY	CHECKED BY	DATE	PROJ. NO.
UPGRADING OF N.A.R.T. BLDG.	PHILIPPINE NUCLEAR RESEARCH INSTITUTE	PUBLIC COMFORT ROOM OF NART BLDG. 2ND & 3RD FLOOR	Eng. JOSEPHINE REYES Senior Engineer Senior Engineer (Architectural)	ANNA N. MILLANUEVA Engr. 538 MA. CALENA W. RAMIRO Chief Engineer SOLIED S. CASTANEDA, Ph.D. Principal Engineer	CHARLO A. ARCOLLA, Ph.D. Director	GERBAZO	GERBAZO	FEB. 26 2020	

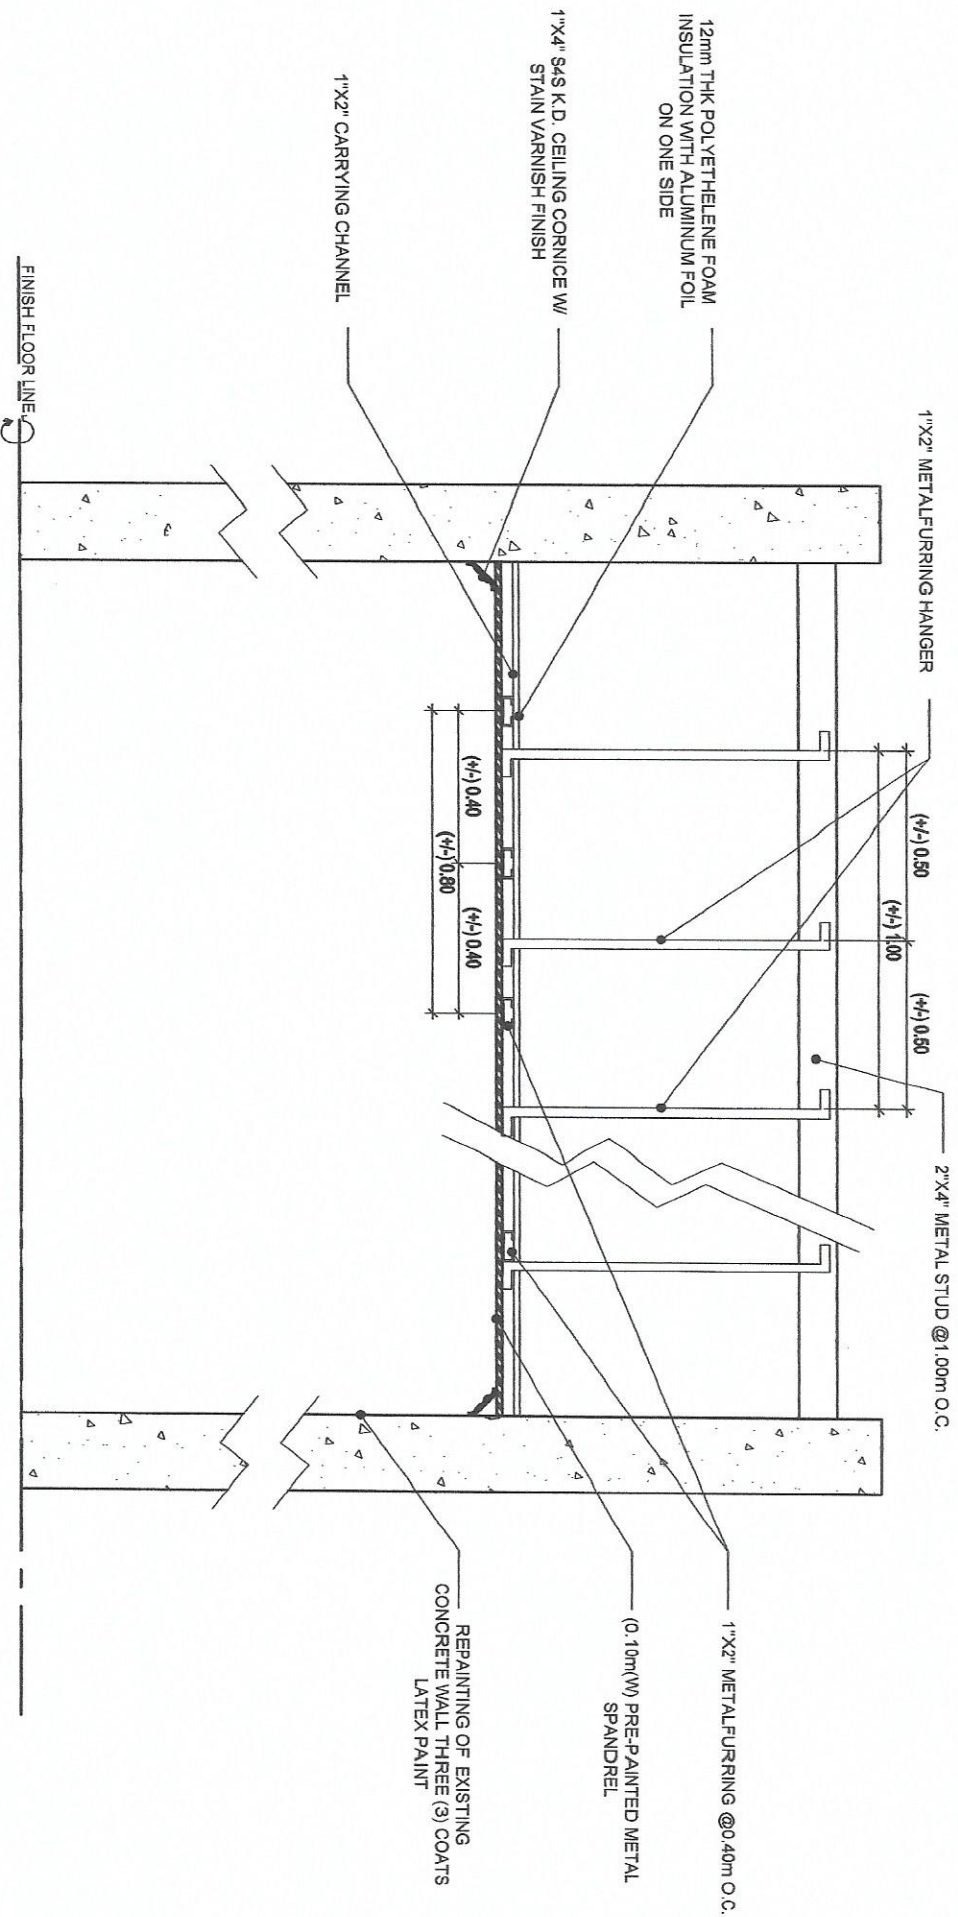

1
SCALE

TYPICAL DETAILS OF PUBLIC COMFORT ROOM CEILING

1:20 MTS



Republic of the Philippines
DEPARTMENT OF SCIENCE AND TECHNOLOGY
PHILIPPINE NUCLEAR RESEARCH INSTITUTE
CAMPUS MARIKINA, MARIKINA CITY

PROJECT
UPGRADING OF
N.A.R.T. BLDG.
(C.Y. 2020)

OWNER
PHILIPPINE NUCLEAR
RESEARCH INSTITUTE

SHEET CONTENT:
TYPICAL DETAILS OF
PUBLIC COMFORT ROOM
CEILING


PREPARED BY:
ENG. ROSALIND B. PEÑAS
Senior Research Scientist
PHILIPPINE NUCLEAR RESEARCH INSTITUTE

RECOMMENDING APPROVAL:
ANITA N. WILLAMUEVA
Head, CES
MA. CECILINA M. RAMIRO
Chief, R&D
PRECEDAS S. CASTAÑEDA, Ph.D.
Division Director


APPROVED BY:
CARLOM. ARCILLA, Ph.D.
Director

DRAWN BY: GENRALDO
CHECKED BY:
DATE: FEB. 26, 2020
PROJ. NO.:


SHEET NO.:
A-14
PAGE NO.:
14/25

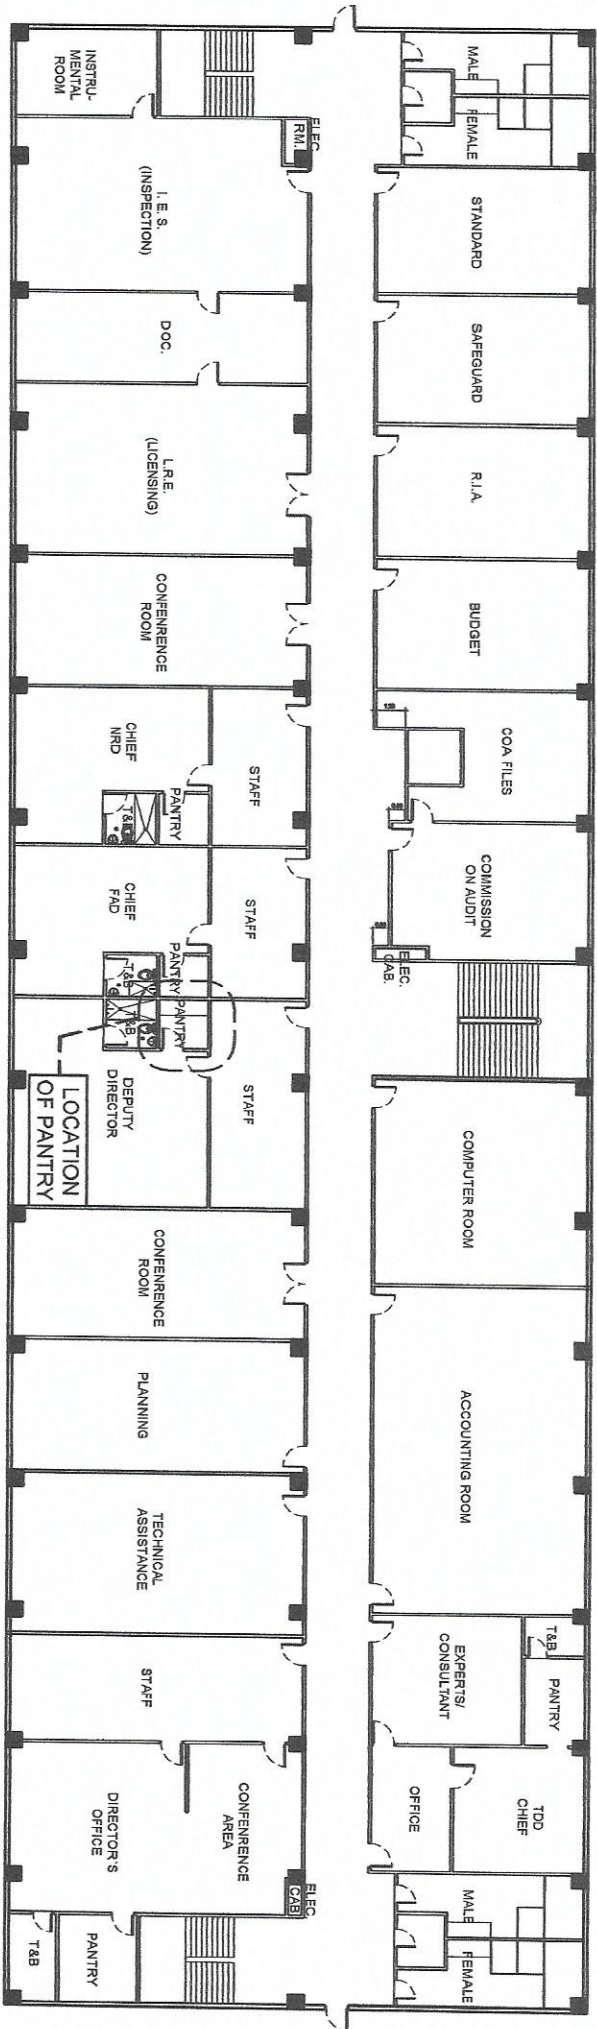


1 THIRD FLOOR OF N.A.R.T. BLDG.
SCALE
NTS

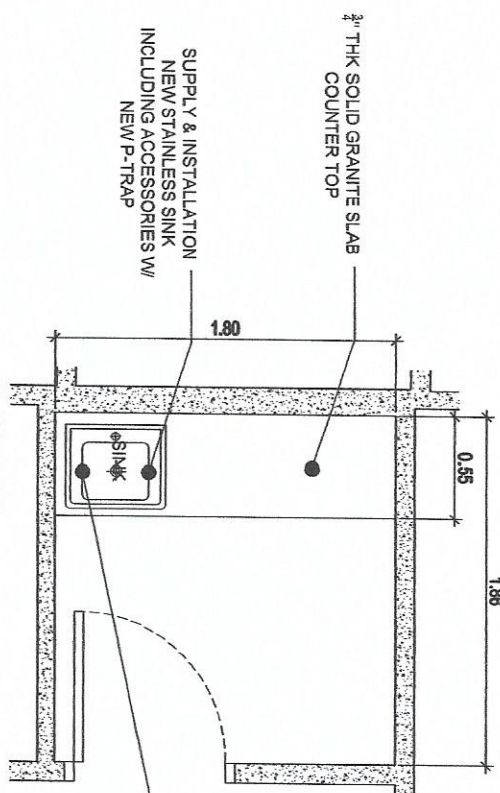

1 PANTRY ROOM
OFFICE OF THE DEPUTY DIRECTOR
SCALE
1:40 MTS

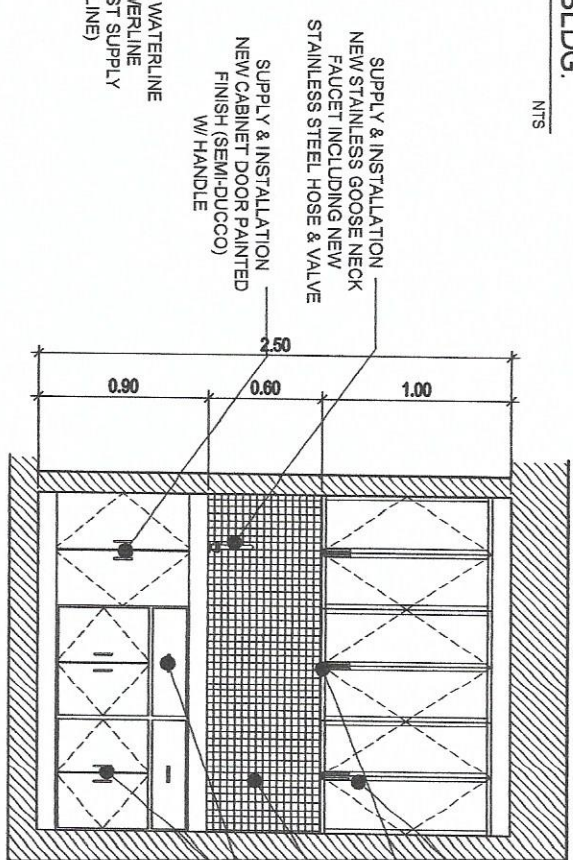


1 SECTION DETAIL OF PANTRY
SCALE
1:40 MTS

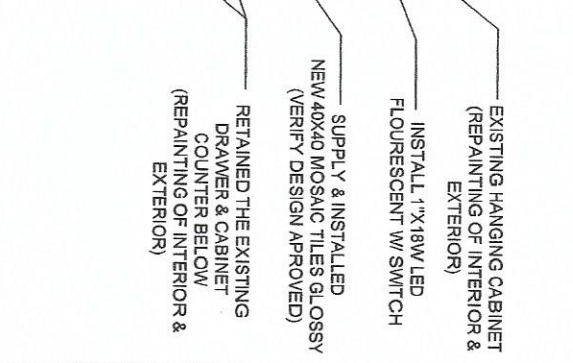


Republic of the Philippines
DEPARTMENT OF SCIENCE AND TECHNOLOGY
PHILIPPINE NUCLEAR
RESEARCH INSTITUTE
COMMONWEALTH AVENUE, DILIMAN, QUEZON CITY

PROJECT:	OWNER:	SHEET CONTENT:	PREPARED BY:	REVIEWING APPROVAL:	APPROVED BY:	DRAWN BY:	CHECKED BY:	SHEET NO.:
UPGRADING OF N.A.R.T. BLDG. (C.Y. 2020)	PHILIPPINES NUCLEAR RESEARCH INSTITUTE	NART BLDG. THIRD FLOOR PLAN - PANTRY ROOM OF DEPUTY DIRECTOR	Engr. ROSALIND REAS Engr. ARLENE SAHJ Engr. ARLENE SAHJ	ANNIE M. ALLENDE M. ALLENDE M. ALLENDE Engr. RENZO J. BARRERA Engr. RENZO J. BARRERA Engr. RENZO J. BARRERA	CARLO A. ARCELA, Ph.D. Engr. CARLO A. ARCELA, Ph.D. Engr. CARLO A. ARCELA, Ph.D.	Engr. CARLO A. ARCELA, Ph.D. Engr. CARLO A. ARCELA, Ph.D. Engr. CARLO A. ARCELA, Ph.D.	Engr. CARLO A. ARCELA, Ph.D. Engr. CARLO A. ARCELA, Ph.D. Engr. CARLO A. ARCELA, Ph.D.	A-15
DATE: FEB 25 2020						THAIL NO.:		15/25

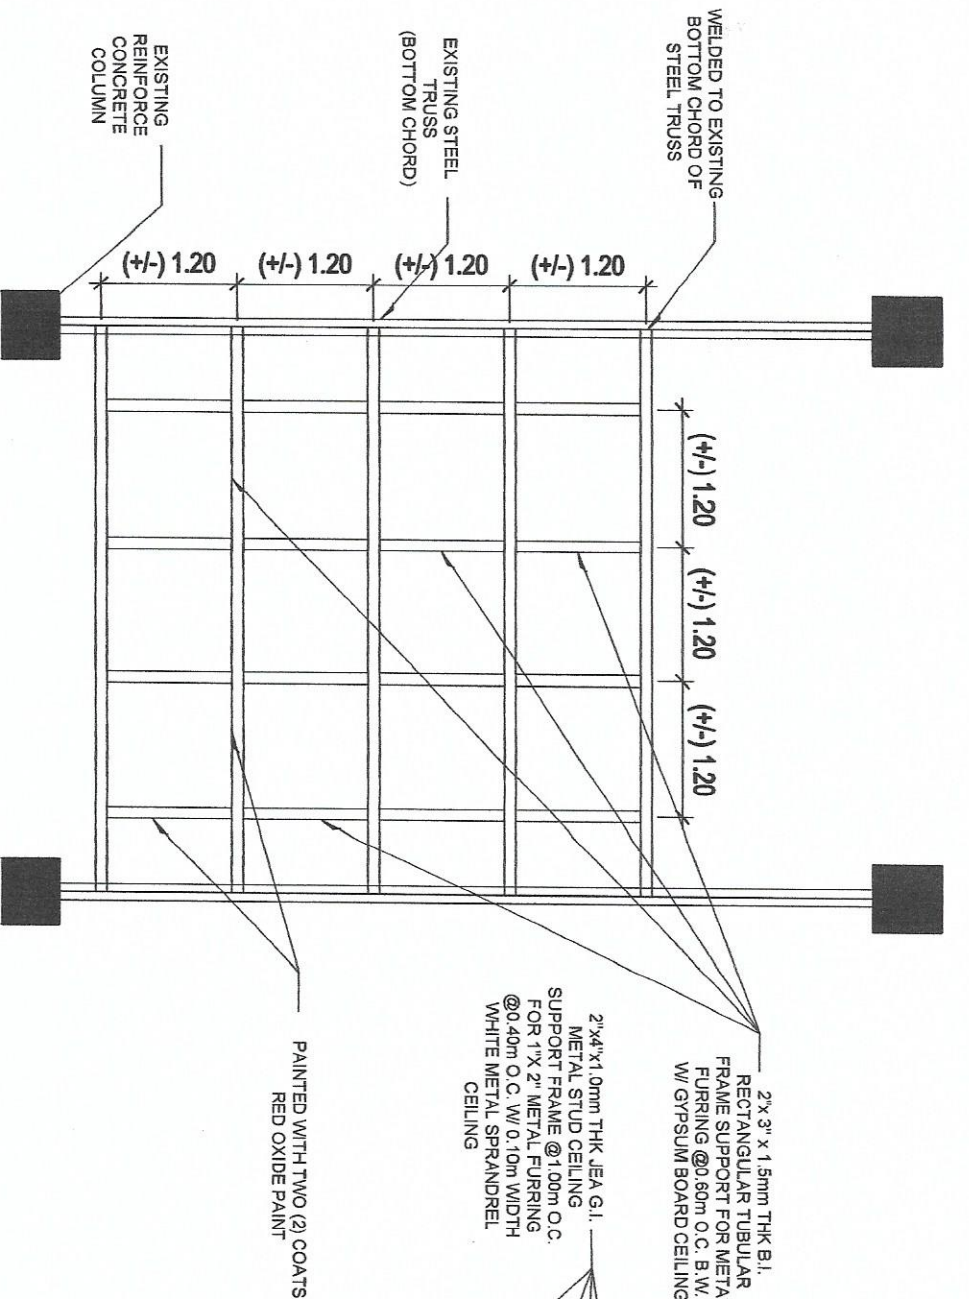

1 OFFICE'S CEILING SUPPORT FRAME
SCALE 1:10 MTS

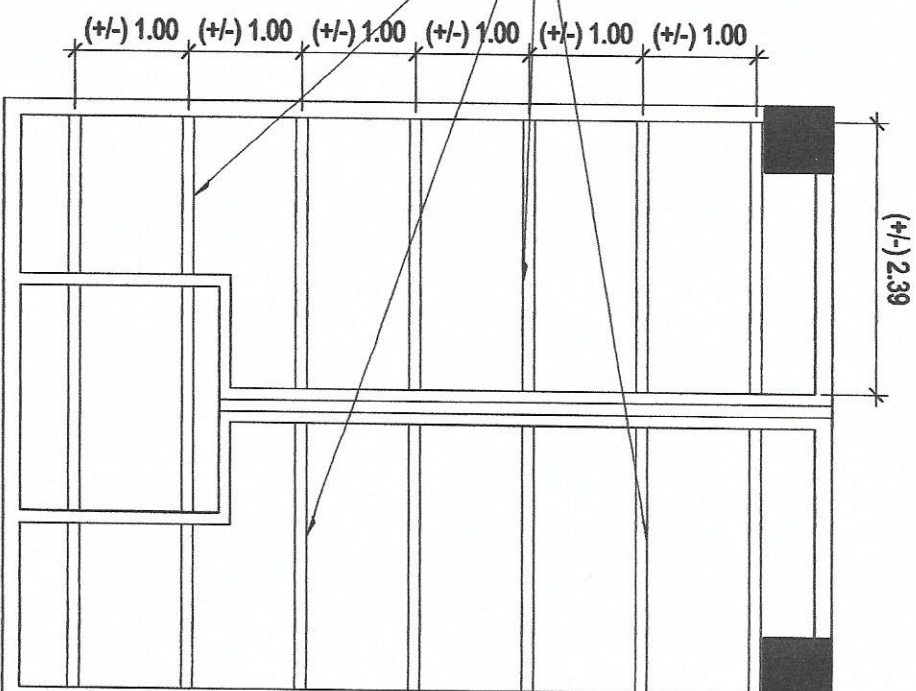


2 PUBLIC COMFORT ROOM CEILING SUPPORT FRAME
SCALE 1:10 MTS




Republic of the Philippines
DEPARTMENT OF SCIENCE AND TECHNOLOGY
PHILIPPINE NUCLEAR RESEARCH INSTITUTE
COMONWEALTH AVENUE, QUEZON CITY


PROJECT:	OWNER:	SHEET CONTENT:	PREPARED BY:	RECOMMENDING PERSONAL:	APPROVED BY:	DRAWN BY:	SHEET NO.:
UPGRADING OF N.A.R.T. BLDG. (C.Y. 2020)	PHILIPPINE NUCLEAR RESEARCH INSTITUTE	CEILING SUPPORT FRAME	ENGR. ROSALIND B. REAS Engr. Rosalind B. Reas Engr. Rosalind B. Reas Engr. Rosalind B. Reas	ANNA N. VILLANUEVA MA. VETERINA N. AMIRO FREDOSA B. PABOJA, M.D. SOLIDAD S. CRISTANEDA, Ph.D.	CARLO A. ARQUILLA, Ph.D.	GENILIZO	A-16
						DATE: FEB. 24, 2020	PAGE NO.:
						16/25	

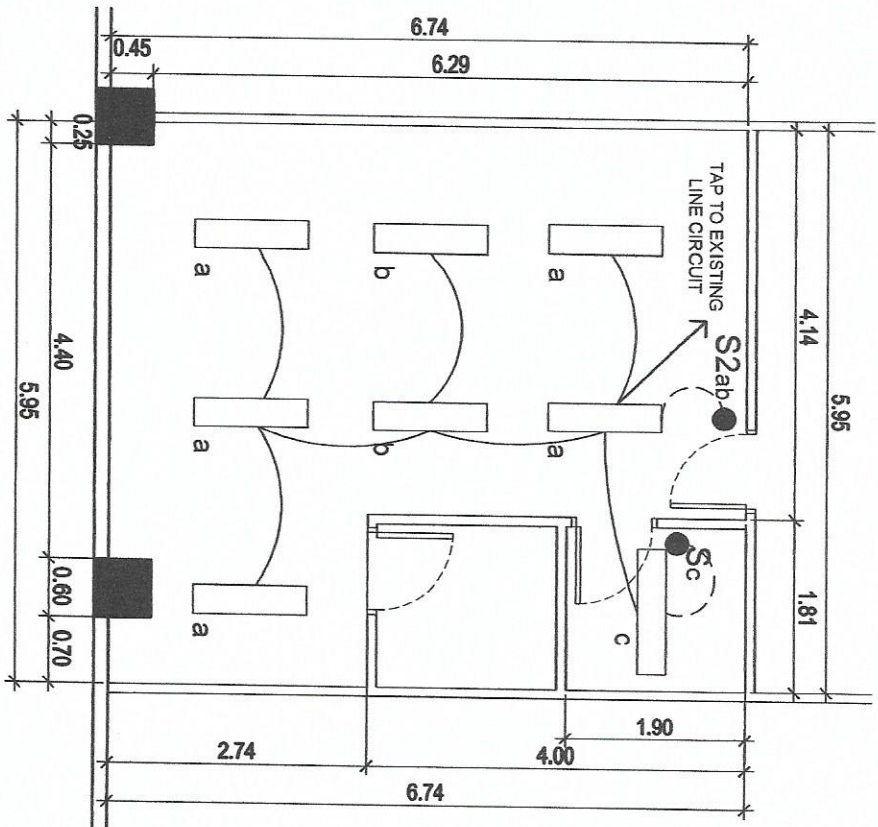

NSD CHIEF OFFICE

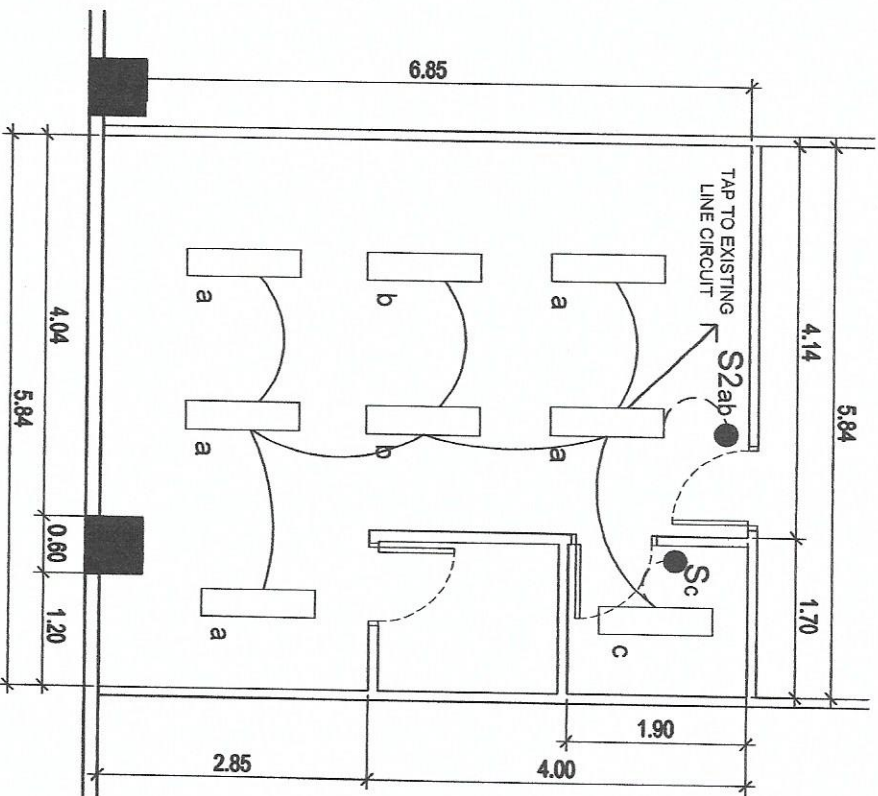

ARD CHIEF OFFICE

 

1 LIGHTING LAYOUT (NART BLDG. - 2ND FLOOR)

1:80 MTS



Republic of the Philippines
DEPARTMENT OF SCIENCE AND TECHNOLOGY
PHILIPPINE NUCLEAR RESEARCH INSTITUTE
COMMONWEALTH AVENUE, DILMAN, CAGAYAN CITY

PROJECT	OWNER	SHEET CONTENT	PREPARED BY	RECOMMENDING APPROVAL	APPROVED BY	DRAWN BY	SHEET NO.
UPGRADING OF NART BLDG. (C.Y. 2020)	PHILIPPINE NUCLEAR RESEARCH INSTITUTE	ELECTRICAL LIGHTING LAYOUT CHIEF'S OFFICES -2ND FLOOR NART BLDG.	Engr. ROSARIO B. PLAS Senior Electrical Engineer Engr. ARTHUR C. SALIN Senior Electrical Engineer	ANITA M. VILLANUEVA Head, G-5 Engr. BENITO T. BANGA Engr. MA. CETERINA M. BANGA Engr. SOLEDAD S. CASTANEDA, Ph.D. Chief, G-5 Deputy Director	CARLO A. ARROLLA, Ph.D. Director	CHECKED BY: DATE: FEB. 26, 2020	E-1 17/25