



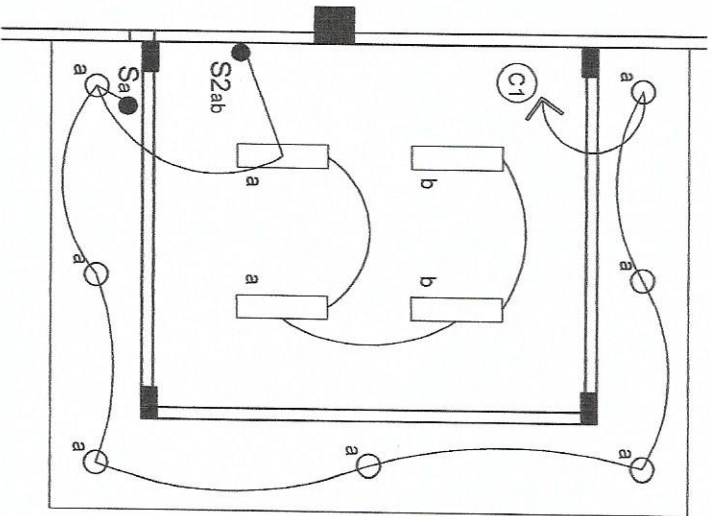


LIGHTING LAYOUT PLAN

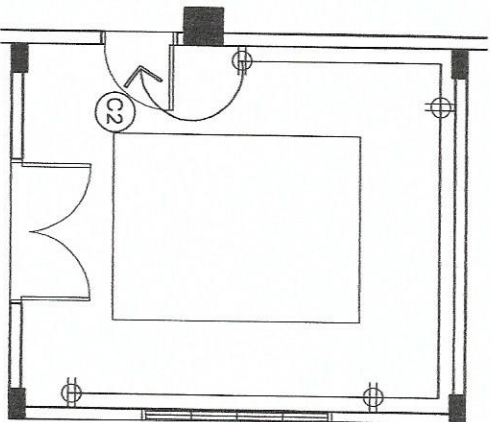


POWER LAYOUT PLAN

	PROJECT	OWNER	SHEET CONTENT	PREPARED BY	RECOMMENDING APPROVAL	APPROVED BY	DRAWN BY	SHEET NO.
Republic of the Philippines DEPARTMENT OF SCIENCE AND TECHNOLOGY PHILIPPINE NUCLEAR RESEARCH INSTITUTE COMMONWEALTH AVENUE, DILIMAN, QUEZON CITY	MOSQUITO MASS REARING FACILITY	PHILIPPINE NUCLEAR RESEARCH INSTITUTE	ELECTRICAL LAYOUT	Engr. RASULNO B. REAS Engr. ARDITHA SANTI Engr. RENATO T. BANAGA HEAD EES	PRECIOUSA B. MABONGA, Ph.D. Chief, EES LUOLLEABDO Ph.D. Chief, AOS SOPHEDDO S. CASTANEDA, Ph.D. Deputy Director	CARLO A. ANICOLA, Ph.D. Director	CHIEF BY: GENRAL ADO DATE: 7/10 PAGE NO: 7/10	E-1

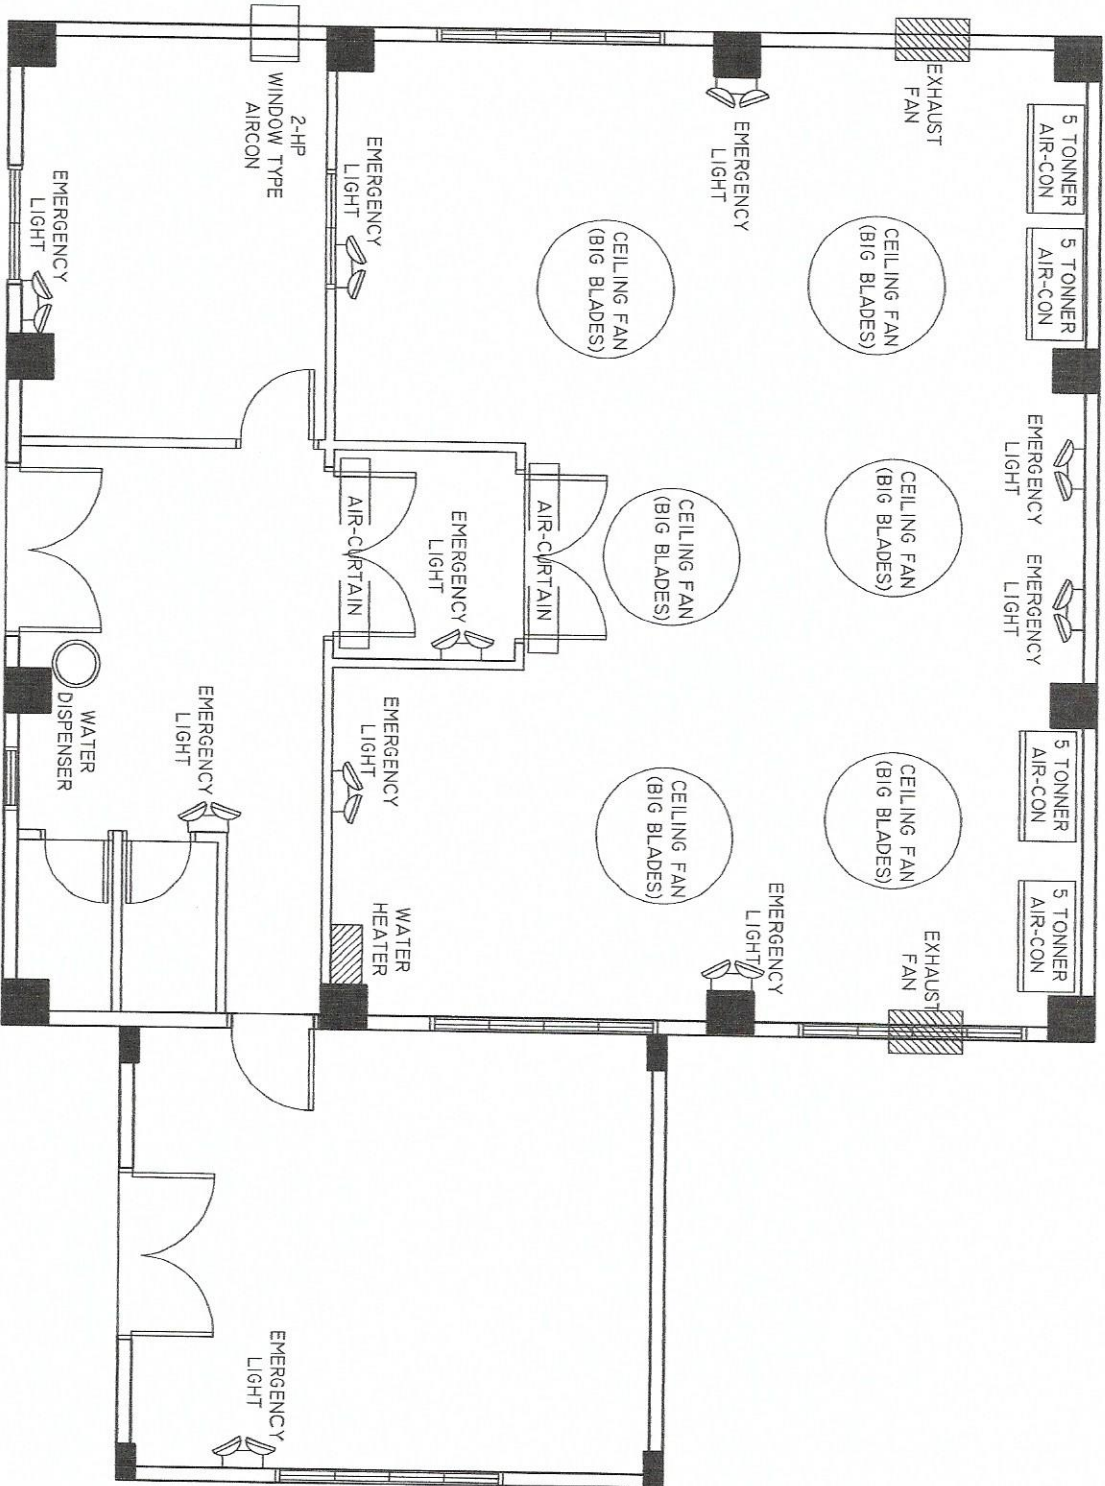


MECHANICAL LAYOUT

 Republic of the Philippines DEPARTMENT OF SCIENCE AND TECHNOLOGY PHILIPPINE NUCLEAR RESEARCH INSTITUTE COMMONWEALTH AVENUE, DILIMAN, QUEZON CITY		PROJECT MOSQUITO MASS REARING FACILITY		OWNER PHILIPPINE NUCLEAR RESEARCH INSTITUTE		SHEET CONTENT MECHANICAL LAYOUT		PREPARED BY Engr. KOSHIKO S. REAS Engr. EDUARDO P. SALAS Engr. REMONTO N. BAYMAGA		RECORDING APPROVAL GENIE B. ORDA, Ph.D. FREDERICKA TORRES, Ph.D. SOLIMAO S. CASTANEDA, Ph.D.		APPROVAL CARLO A. ARCILLA, Ph.D.		DRAWN BY: GENILAO CHECKED BY: DATE: PART NO. 8/10	
--	--	---	--	--	--	------------------------------------	--	--	--	---	--	-------------------------------------	--	---	--

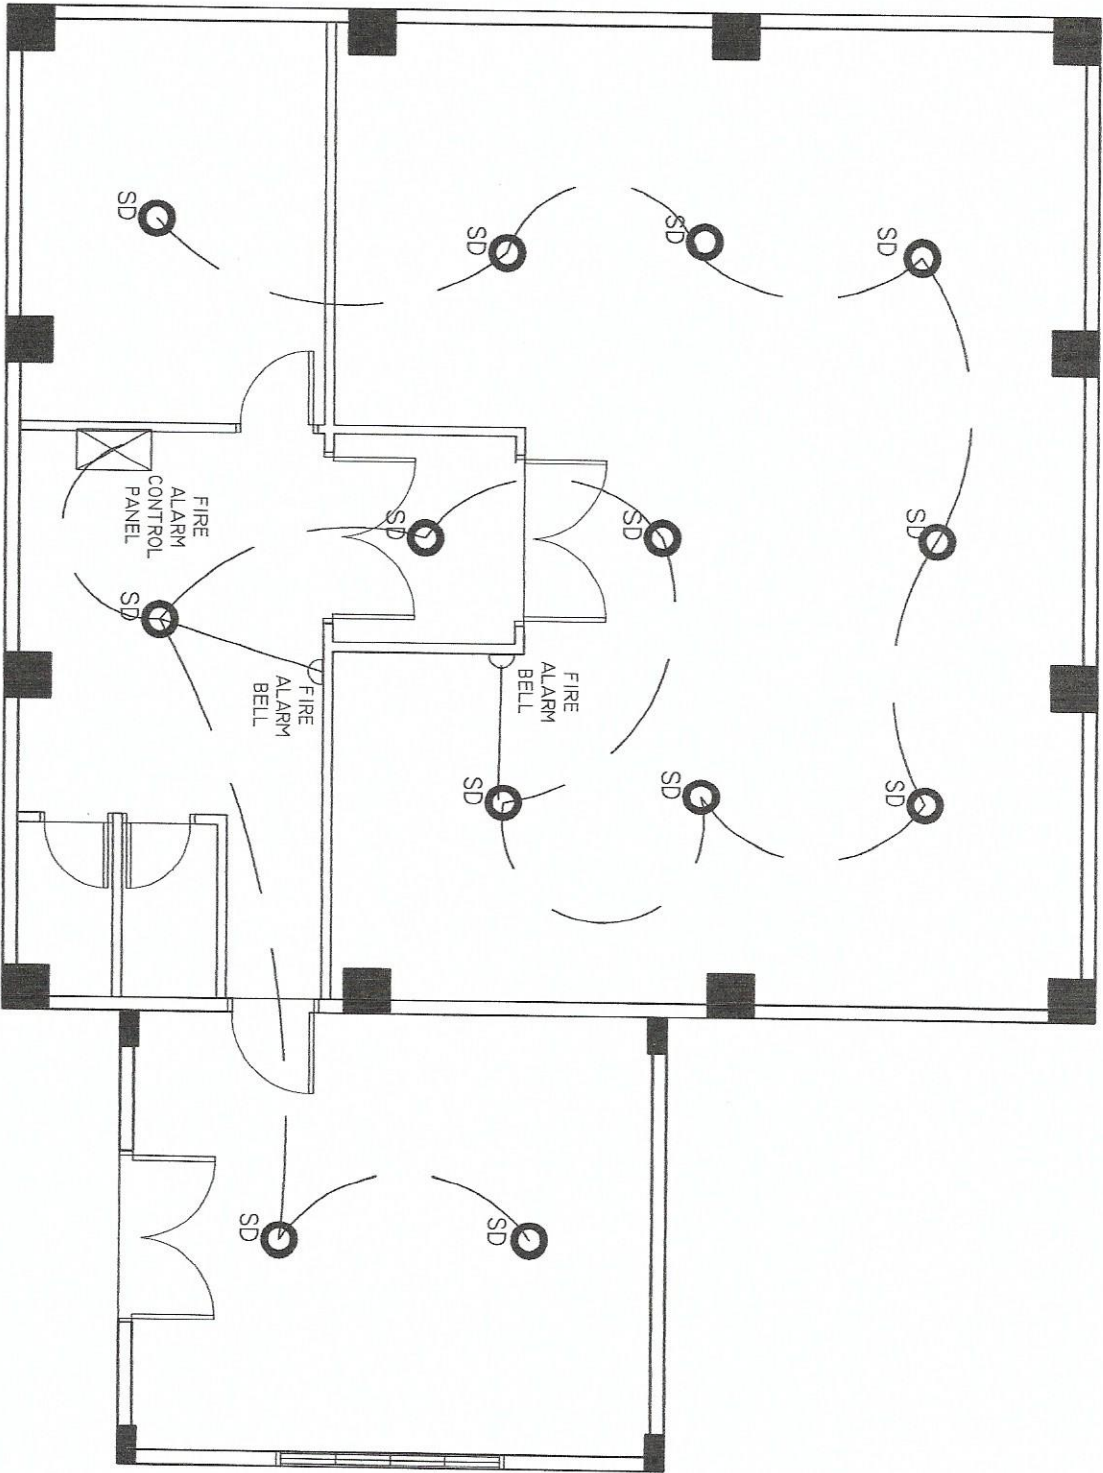

SMOKE DETECTOR LAYOUT

 Republic of the Philippines DEPARTMENT OF SCIENCE AND TECHNOLOGY PHILIPPINE NUCLEAR RESEARCH INSTITUTE COMMONWEALTH AVENUE, DUMAY, QUEZON CITY		PROJECT MOSQUITO MASS REARING FACILITY		OWNER PHILIPPINE NUCLEAR RESEARCH INSTITUTE		SHEET CONTENT SMOKE DETECTOR LAYOUT		PREPARED BY ENR. ROSALYN B. REYES ENR. RICHARD A. SALIN ENR. REMOTI B. MANGA		REVIEWED AND APPROVAL GUINAY B. OBRA, Ph.D. PREMIL B. MABROA, Ph.D. SOLEDAD S. CASTANEDA, Ph.D.		APPROVED BY CARLO A. ARCILLA, Ph.D.		DRAWN BY: GENILADO CHECKED BY: DATE: PROJECT NO.: 9/10	
--	--	---	--	--	--	--	--	---	--	--	--	--	--	---	--

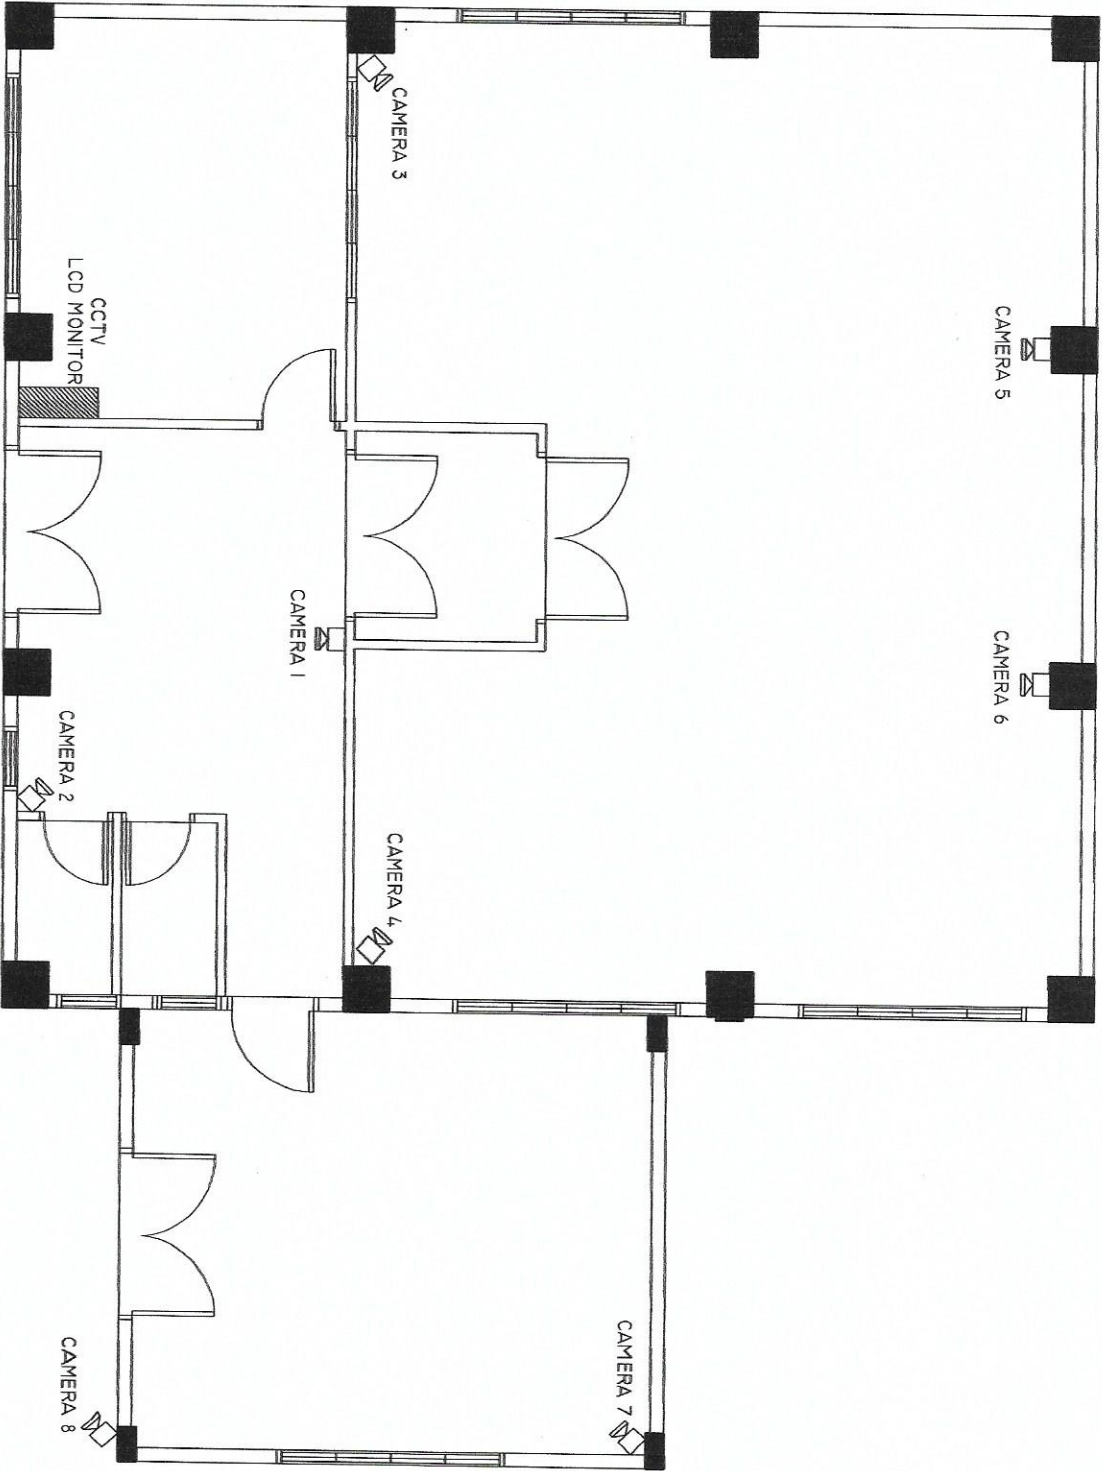

CCTV CAMERA LAYOUT

 Republic of the Philippines DEPARTMENT OF SCIENCE AND TECHNOLOGY COMMISSION ON NUCLEAR ENERGY		PROJECT MOSQUITO MASS REARING FACILITY		OWNER PHILIPPINE NUCLEAR RESEARCH INSTITUTE		SHEET CONTENTS CCTV CAMERA LAYOUT		PREPARED BY ENGR. NERIALINO B. REAS Senior Research Scientist ENGR. ARDITO A. SANTIAGO Senior Research Scientist NOTED BY ENGR. ROMATO T. BANGGAG Senior Research Scientist		REVIEWING AND APPROVAL GLENNY ORTA, Ph.D. Senior Research Scientist PREVIOUS APPROVAL GLENNY ORTA, Ph.D. Senior Research Scientist LUCILLE ARBO, Ph.D. Senior Research Scientist SOLEAD S. CASTANEDA, Ph.D. Senior Research Scientist		APPROVED BY CARLOS ARDILLA, Ph.D. Director		DRAWN BY GABRIEL ORTIZ, Ph.D.		SHEET NO. E-4	
ADDRESS: COMMISSION ON NUCLEAR ENERGY, DILIMAN, QUEZON CITY		DATE: _____		PROJECT NO.: _____		PAGE NO.: _____		10/10									



MOSQUITO
MASS REARING
FACILITY
(C.Y. 2019)

PHILIPPINE NUCLEAR
RESEARCH INSTITUTE

**ELECTRICAL
POWER SUPPLY**

Engr. ROSALIND B. REYES
Senior Science Research Specialist
Engr. ARICORIO T. SALITA
Senior Science Research Specialist
Engr. REMATO T. BAÑAGA
ESS Head


RECOMMENDING APPROVAL
 GLENDA R. OBRA, Ph. D.
 Endocrine and ARS
 Preciosa B. Pabros, Ph.D.
 Chem. NSD

LUCILLE ABAD, Ph. D.
Chief, AND

SOLEDAD S. CASTAÑEDA, Ph. D.
Deputy Director

CARLO A. ARCILLA, Ph.D.
Director

DRAWN BY: GENBLAZO	SHEET NO.
CHECKED BY:	
DATE :	PAGE NO. :
PROJ. NO. :	

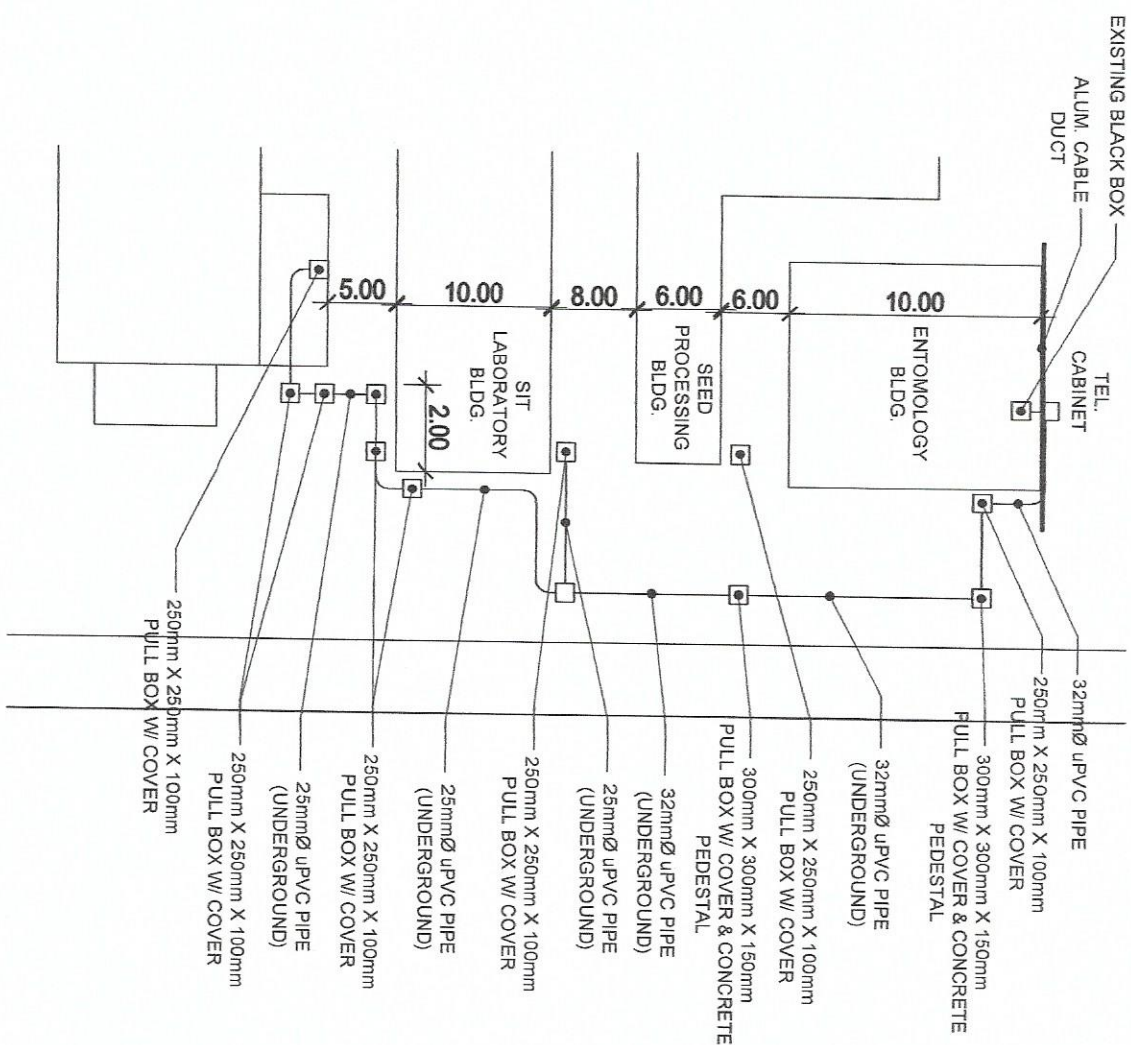

NOTE:

1. PULLBOX W/ CONCRETE PEDESTAL
(300mm X 300mm X 150mm)
2. WALL MOUNTED PULLBOX W/ COVER
(250mm X 250mm X 100mm)