

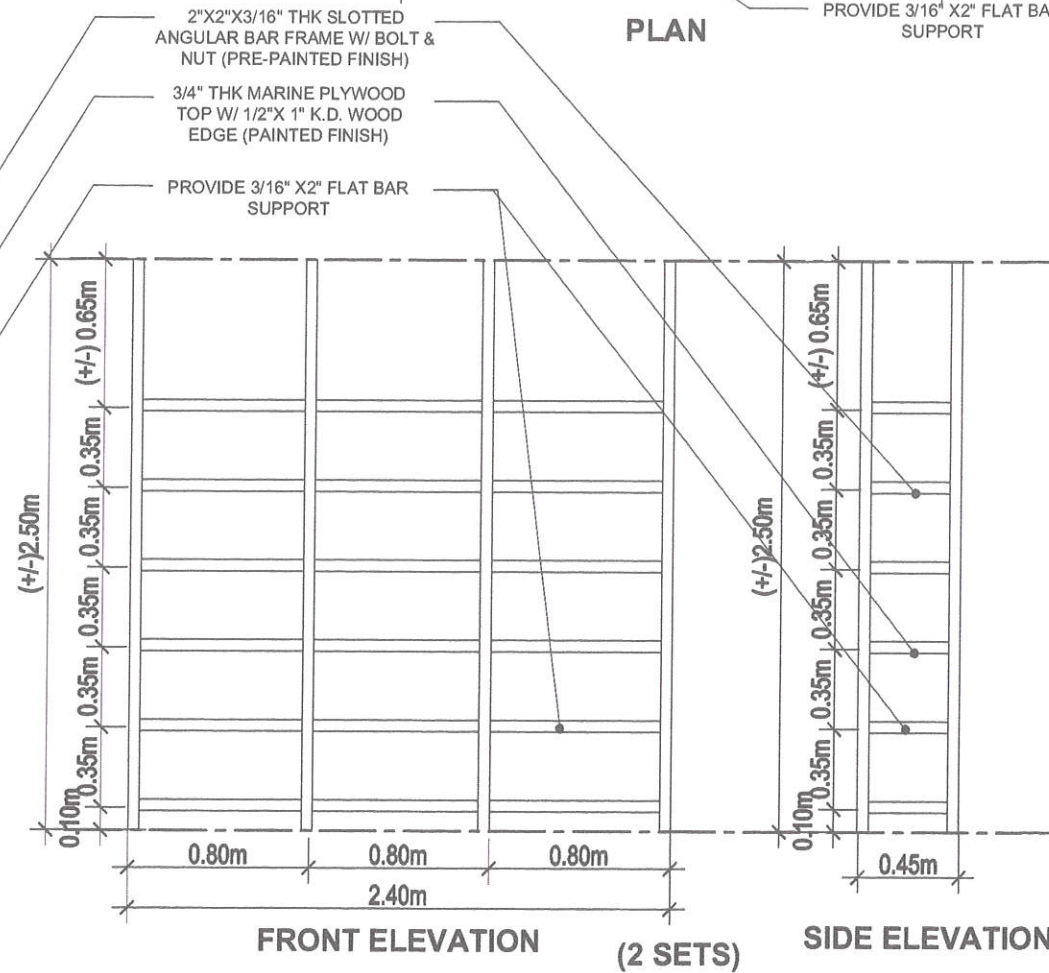
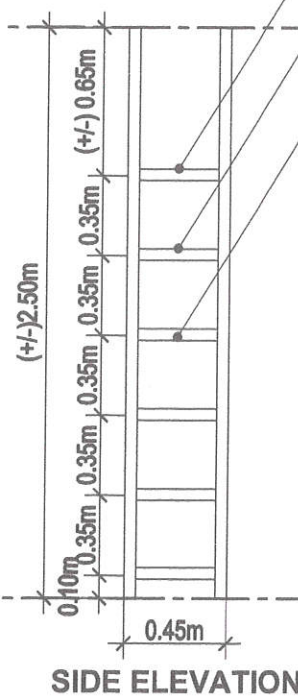
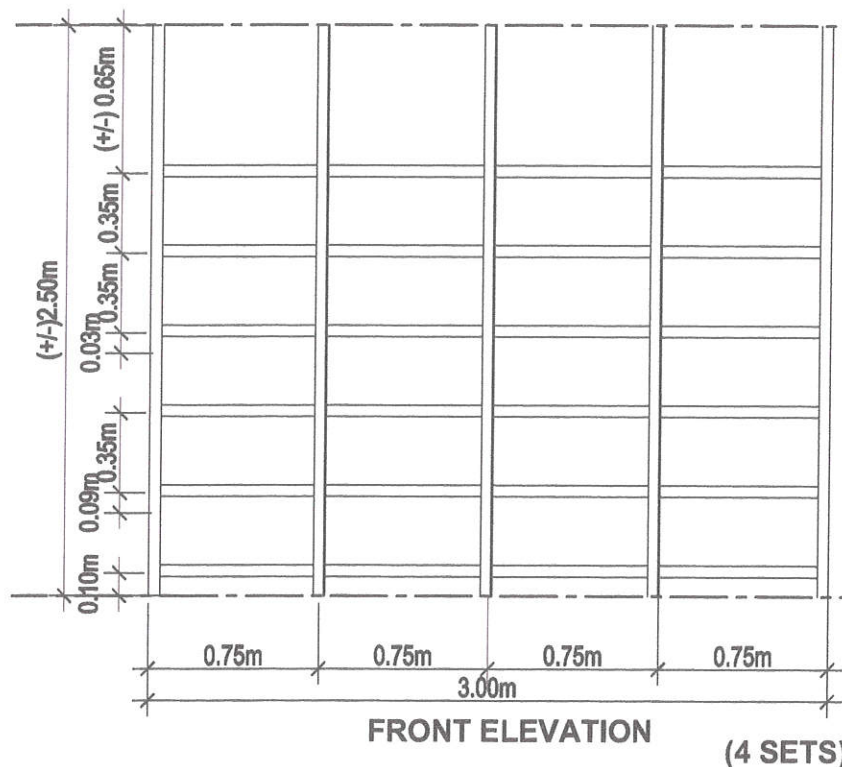


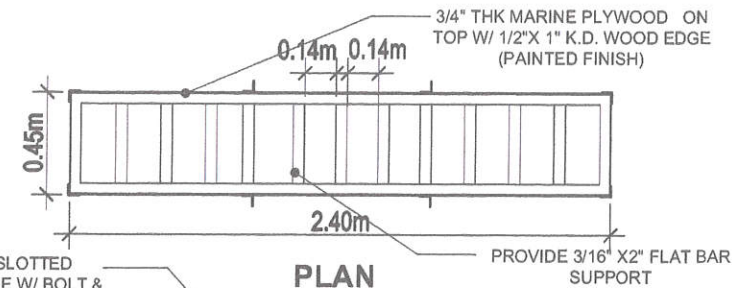

1 **TYPICAL DETAIL OF BUILT-IN OPEN STEEL SHELVES**
SCALE NTS

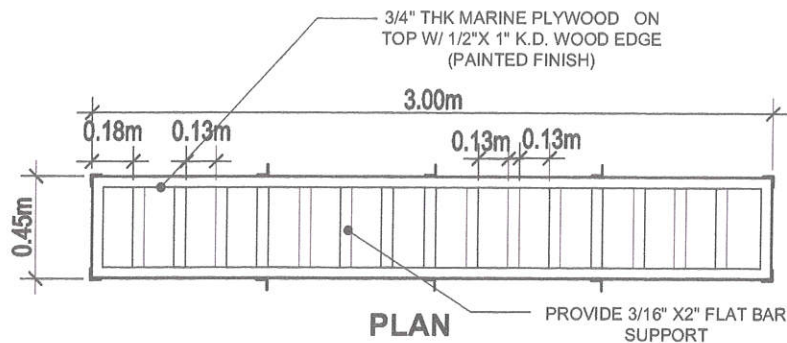

Republic of the Philippines
DEPARTMENT OF SCIENCE AND TECHNOLOGY
PHILIPPINE NUCLEAR RESEARCH INSTITUTE
COMMONWEALTH AVENUE, DILIMAN, QUEZON CITY

PROJECT	SHEET CONTENT	PREPARED BY	RECOMMENDING APPROVAL	APPROVED BY	DRAWN BY	SHEET NO.
UPGRADING OF N.A.R.T BLDG. (C.Y. 2021)	DETAILS OF BUILT-IN OPEN STEEL SHELVES	Engr. ROSALYN B. REJAS Senior Science Research Specialist Engr. ARTURO F. SALIN Senior Science Research Specialist Engr. ANDREW C. BARRIDA Engineer I/ESS	GERARDO JOSE M. ROBLES Engineer Head GSS MA. CELERINA M. RAMIRO Chief, FAD PRECILISA CORAZON B. FABROA Ph. D. Chief, NSD LUCILLE ABAD, Ph. D. OIC, Deputy Director	Engr. RENE TO T. BANAGA ESS Head CARLO A. ARULLA, Ph. D. Director	CHECKED BY: DATE: JULY 09, 2021 PROJ. NO.:	A-16 PAGE NO. 16/39




1 PERSPECTIVE VIEW OF NRD CONFERENCE ROOM
SCALE NTS



Republic of the Philippines
DEPARTMENT OF SCIENCE AND TECHNOLOGY
PHILIPPINE NUCLEAR RESEARCH INSTITUTE
COMMONWEALTH AVENUE, DILMAN, QUEZON CITY

PROJECT:	SHEET CONTENT:	PREPARED BY:	RECOMMENDING APPROVAL:	APPROVED BY:	DRAWN BY: GENBLAZO	SHEET NO.:
UPGRADING OF N.A.R.T BLDG. (C.Y. 2021)	NRD CONFERENCE ROOM - PERSPECTIVE VIEW	Engr. ROSALYN B. REJAS Senior Science Research Specialist Engr. ARTURO F. SALIH Senior Science Research Specialist Engr. ANDREW C. BARRIDA Engineer EBS	GERARDO JOSE M. ROBLES Engr. Lead QSS MA. CELERINA M. RAMIRO CHIEF, PAD PRECOSA CORALYN B. PABROA, Ph.D. Chief, NSO LUCILLE Y. ABAD, Ph.D. OIC, Deputy Director	Engr. RENATO T. BANAGA ESS Head CARLO MARCILIA, Ph.D. Director	CHECKED BY: DATE: JULY 09, 2021 PROJ. NO.:	A-17 PAGE NO.: 17/39

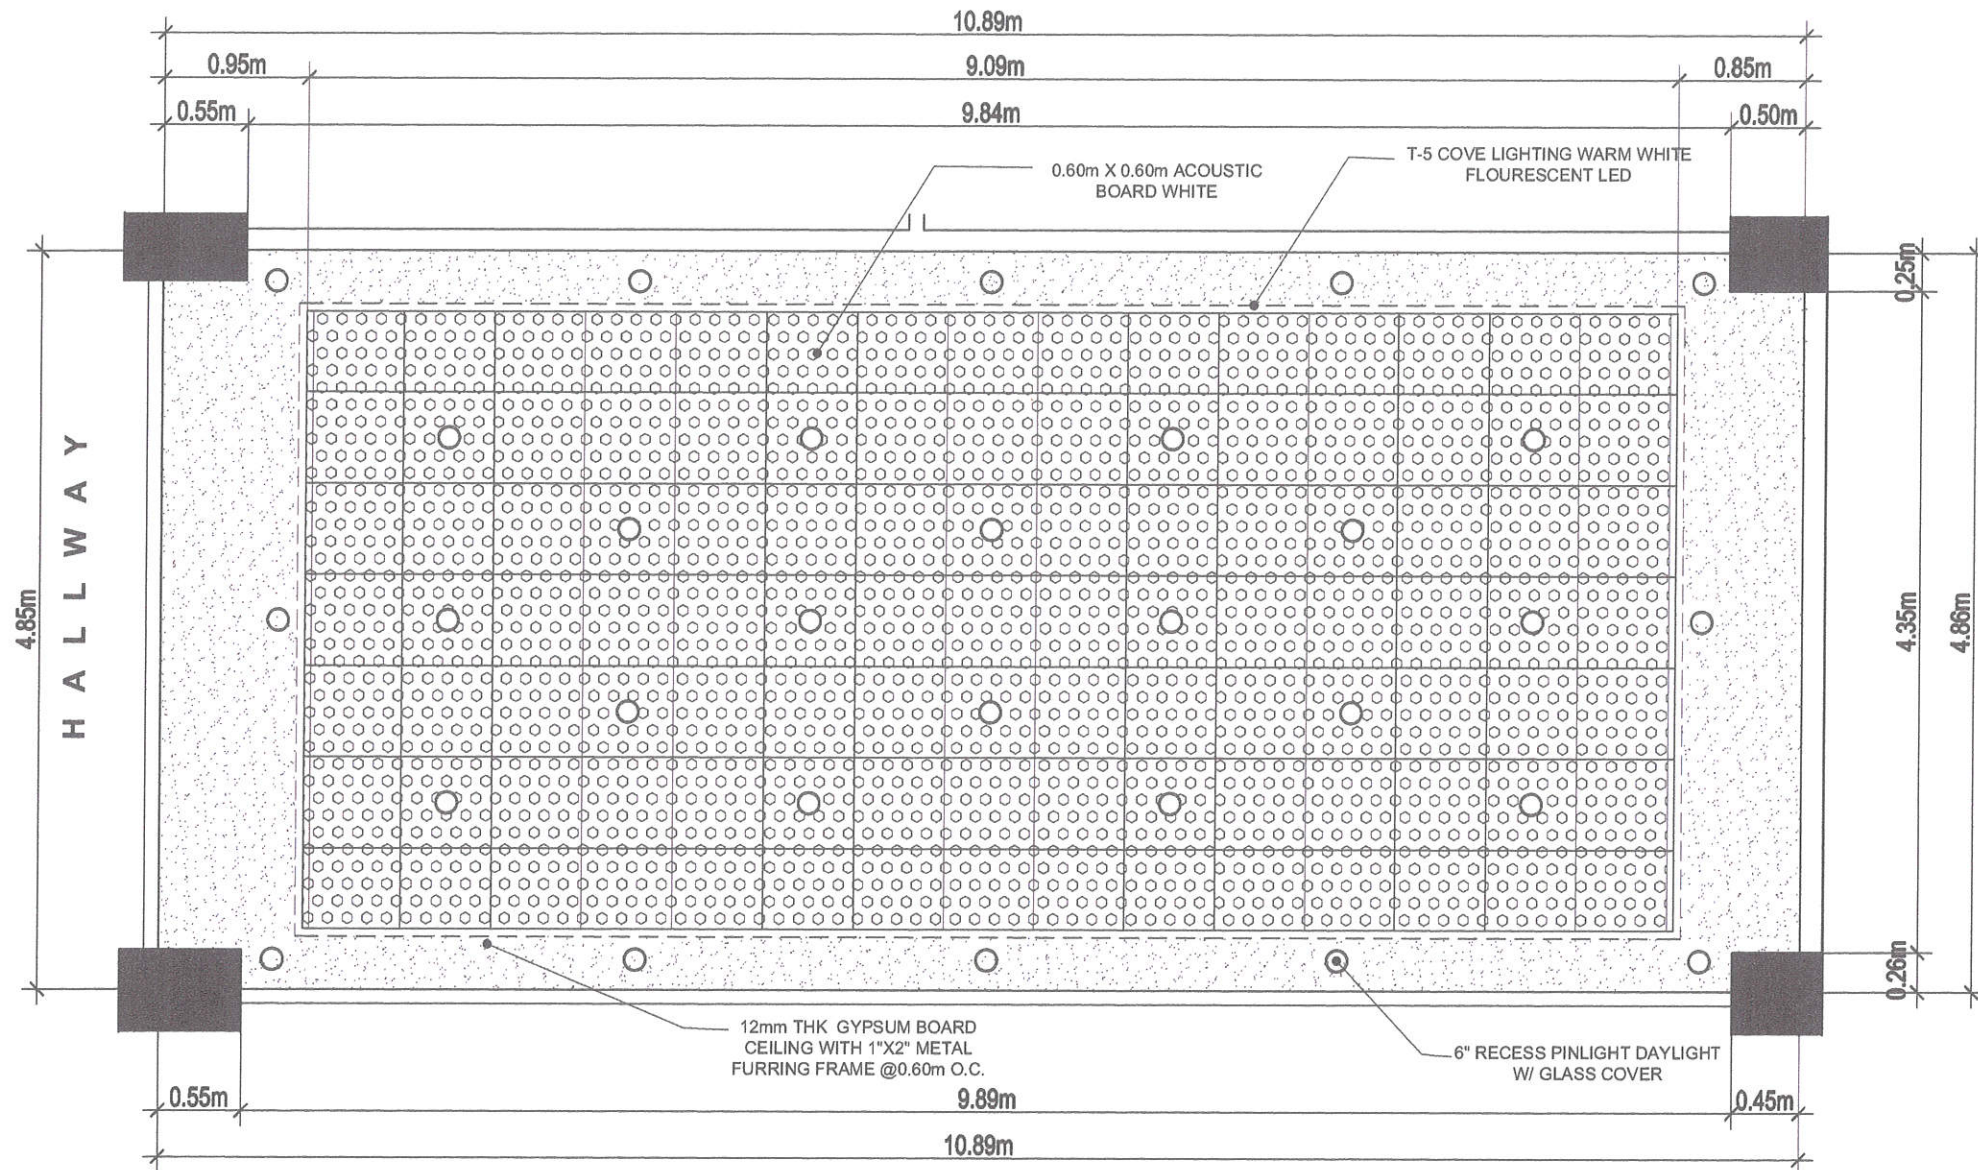

NRD CONFERENCE ROOM - REFLECTED CEILING PLAN


SCALE

NTS



Republic of the Philippines
DEPARTMENT OF SCIENCE AND TECHNOLOGY
PHILIPPINE NUCLEAR RESEARCH INSTITUTE
COMMONWEALTH AVENUE, DILMAN, QUEZON CITY

PROJECT:	SHEET CONTENT:	PREPARED BY:	RECOMMENDING APPROVAL:	APPROVED BY:	DRAWN BY: GENBLAZO	SHEET NO.:
UPGRADING OF N.A.R.T BLDG. (C.Y. 2021)	NRD CONFERENCE ROOM - REFLECTED CEILING PLAN	Engr. ROSALIND B. REAS Senior Science Research Specialist Engr. ARTURO F. SALIN Senior Science Research Specialist Engr. ANDREW C. BARRERA Engineer I, ESB	GERARDO JOSE M. ROBLES Engr. Chief Head QSB MA. CELERINA M. RAMIRO CHIEF, FAD PRECIOUS CORAZON B. FABROA Ph.D. Chief, NSD LUCILLE V. ABAD Ph.D. OIC, Deputy Director	Engr. REMATO T. BANAGA ESB Head CARLO A. BULLA, Ph.D. Director	CHECKED BY: DATE: JULY 09, 2021 PROJ. NO.:	A-18 PAGE NO.: 18/39

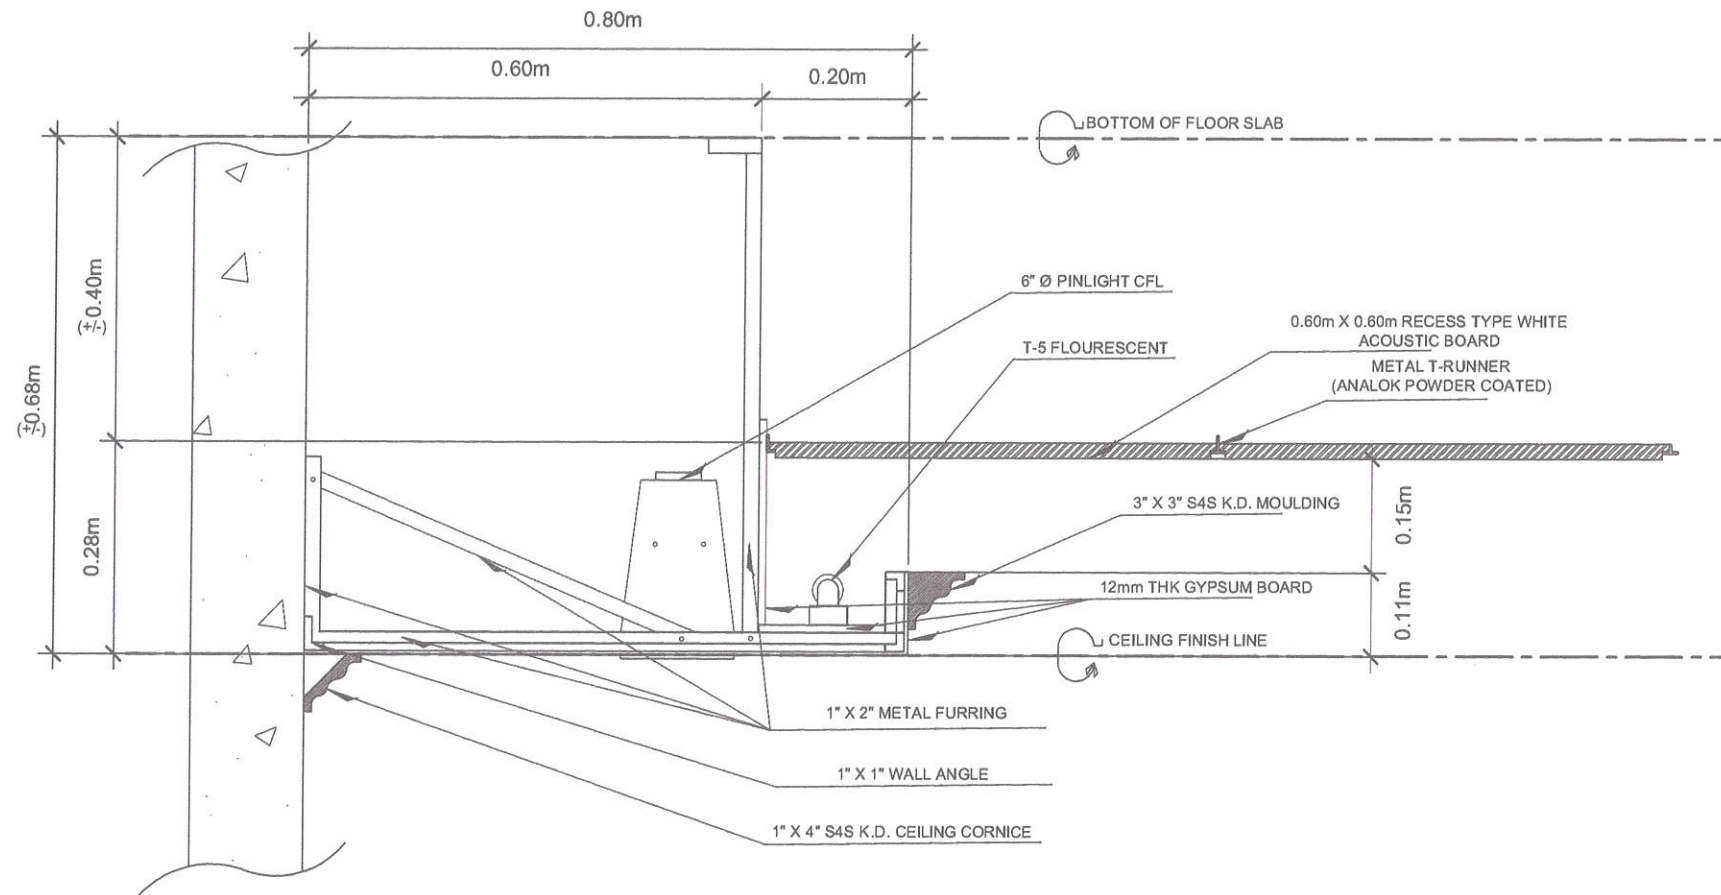

1
SCALE


NRD CONFERENCE ROOM - NART BLDG.
DETAIL OF PINLIGHT & COVELIGHT DROP CEILING

1:10 MTS



Republic of the Philippines
DEPARTMENT OF SCIENCE AND TECHNOLOGY
PHILIPPINE NUCLEAR RESEARCH INSTITUTE
COMMONWEALTH AVENUE, DILMAN, QUEZON CITY

PROJECT:	SHEET CONTENT:	PREPARED BY:	RECOMMENDING APPROVAL:	APPROVED BY:	DRAWN BY: GENBLAZO	SHEET NO.:
UPGRADING OF N.A.R.T BLDG. (C.Y. 2021)	DETAIL OF PINLIGHT & COVELIGHT DROP CEILING IN NRD CONFERENCE	Engr. ROSALINO B. REJAS Senior Science Research Specialist Engr. ANDREW C. BARRIDA Engineer / ESS	Engr. ARTURO F. SANTI Senior Science Research Specialist GERARDO JOSE M. ROBLES Engr. JUAN MIGUEL GSB MA. CELERINA M. RAMIRO CHIEF, F&D PRECIOSA CORAZON B. PABROA Ph. D. Chief, NSO	Engr. RENATO T. BANAGA ESS Head CARLO A. RECILLA Ph. D. Director	CHECKED BY:	A-19
					DATE: JULY 09, 2021	PAGE NO.:
					PROJ. NO.:	19/39

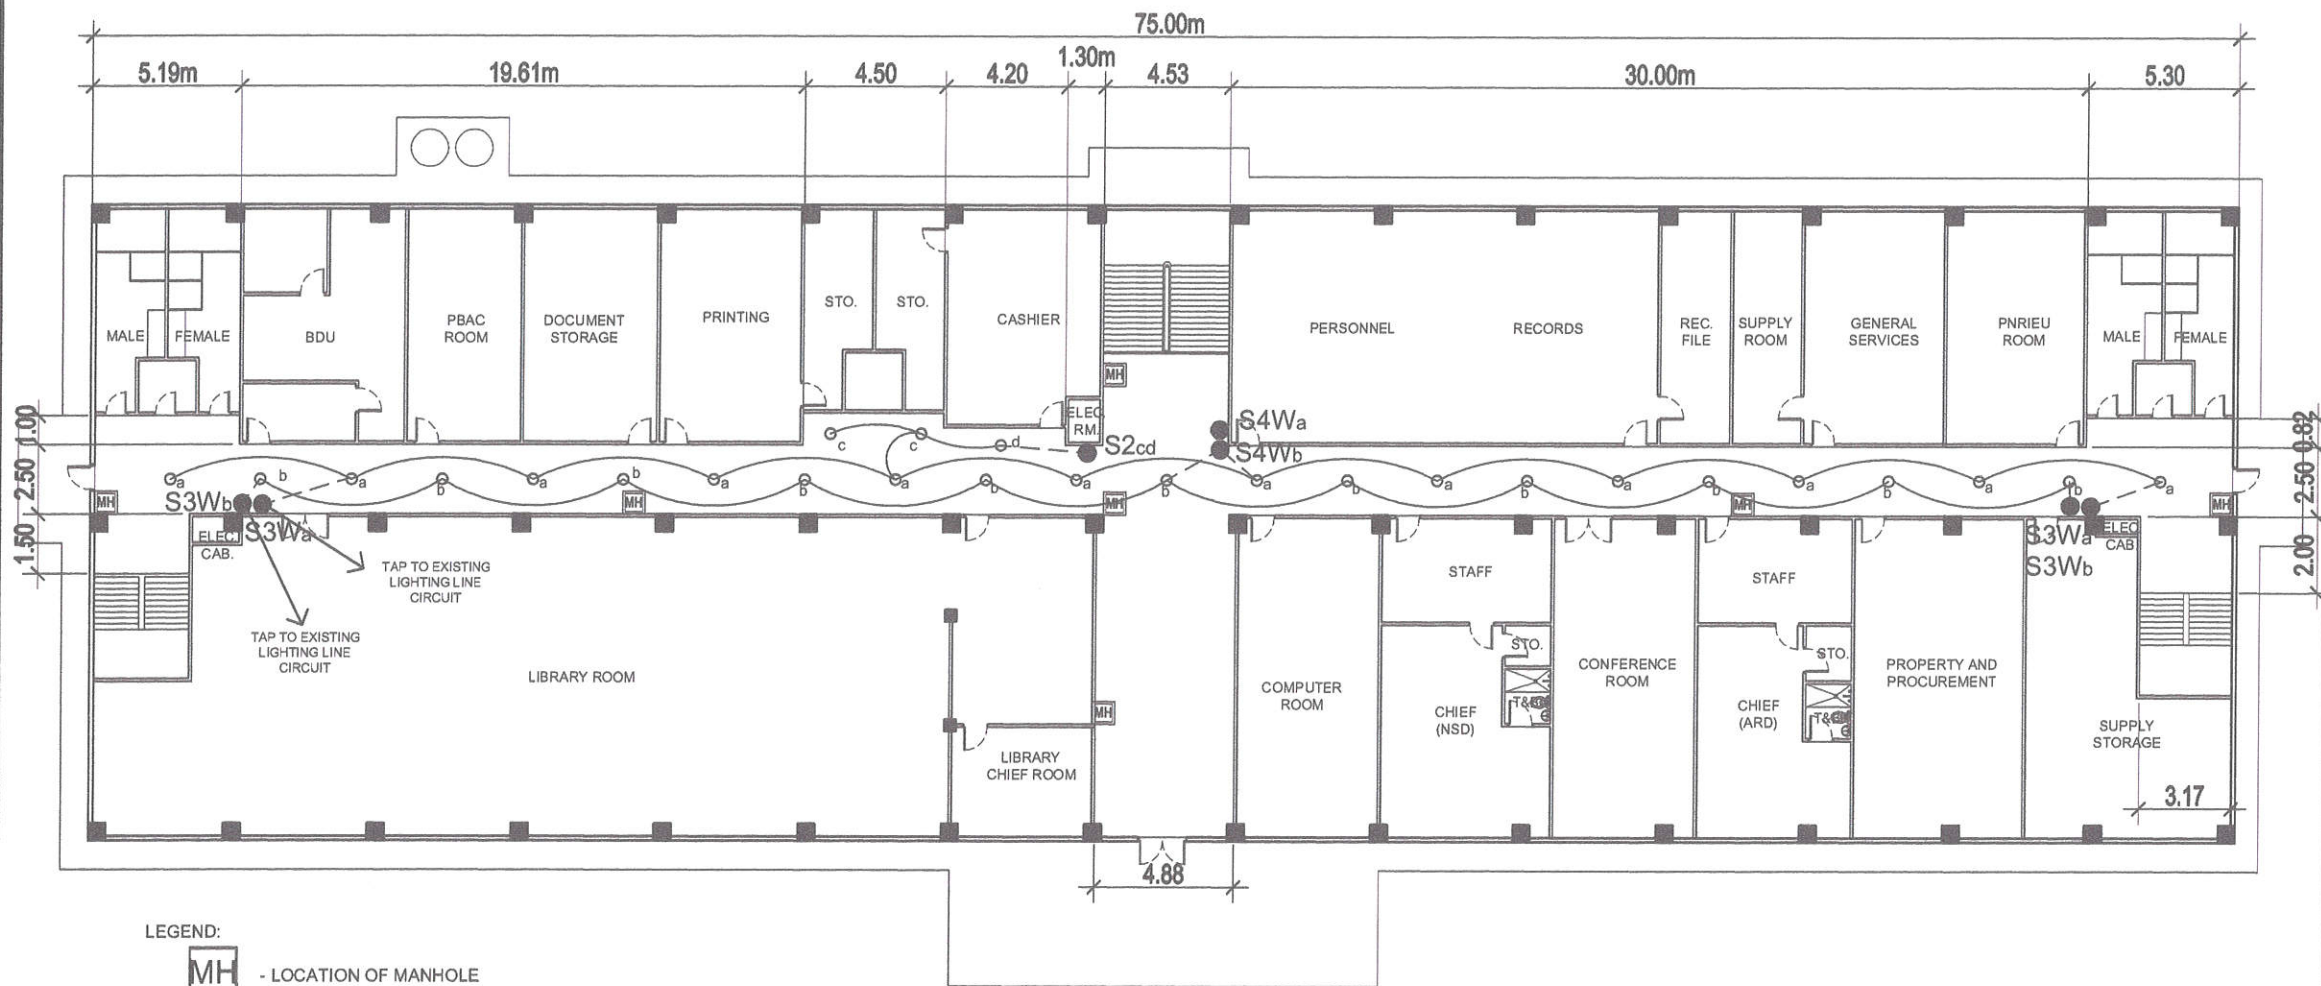


1 SECOND FLOOR HALLWAY LIGHTING LAYOUT
SCALE NTS




Republic of the Philippines
DEPARTMENT OF SCIENCE AND TECHNOLOGY
PHILIPPINE NUCLEAR RESEARCH INSTITUTE
COMMONWEALTH AVENUE, DILIMAN, QUEZON CITY


PROJECT:	SHEET CONTENT:	PREPARED BY:	RECOMMENDING APPROVAL:	APPROVED BY:	DRAWN BY: GENSLAZO	SHEET NO.:
UPGRADING OF N.A.R.T BLDG. (C.Y. 2021)	SECOND FLOOR HALLWAY CEILING PLAN	Engr. ROSALINO B. REJAS Senior Science Research Specialist Engr. ARTURO F. SALIH Senior Science Research Specialist Engr. ANDREW C. BARRIDA Engineer I, ESS	GERARDO J. M. ROBLES Engr. BENATO T. BANIAGA Engr. MA. CELERINA M. RAMIRO CHIEF, FAD PRECIOSA CORAZON B. PABROA Ph. D. CHIEF, NSD LUCILLE Y. ABAD, Ph. D. OIC, Deputy Director	CARLO A. ARULLA, Ph. D. Director	CHECKED BY: DATE: JULY 09, 2021 PROJ. NO.:	E-1 PAGE NO.: 20/39

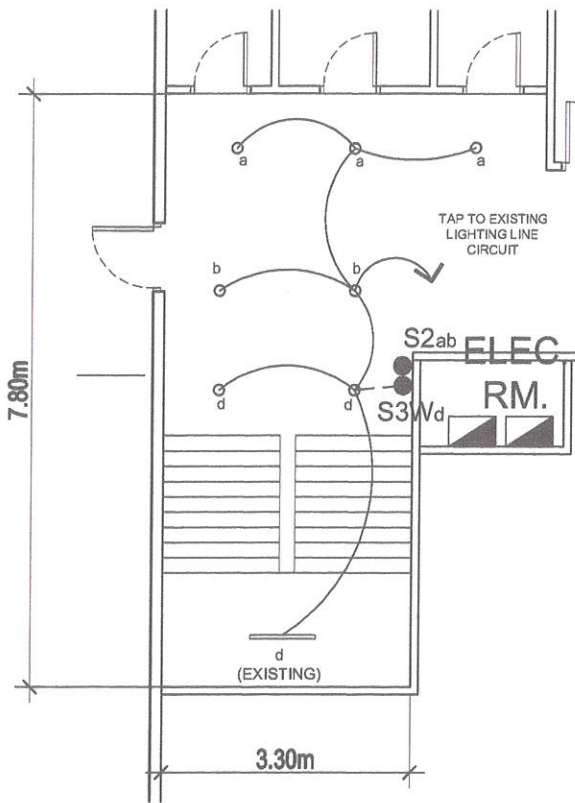

1
LEFT WING
SECOND FLOOR PLAN
SCALE NTS

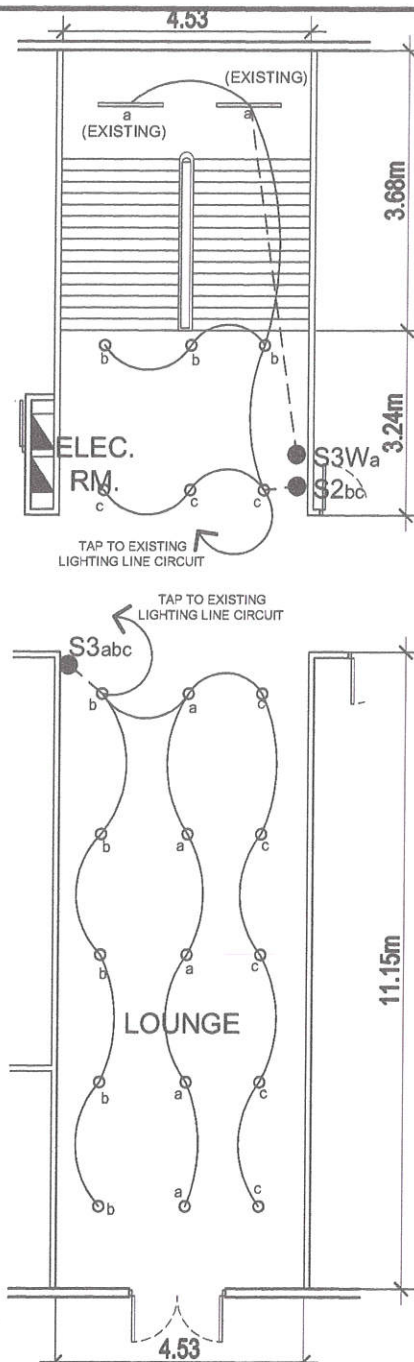

2
MIDDLE HALLWAY
SECOND FLOOR PLAN
SCALE NTS

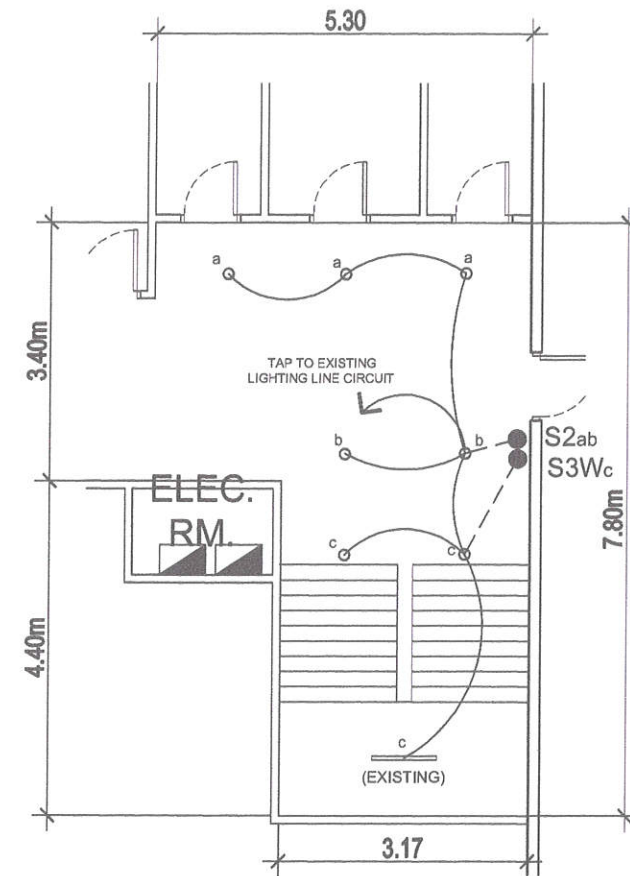


3
RIGHT WING
SECOND FLOOR PLAN
SCALE NTS



Republic of the Philippines
DEPARTMENT OF SCIENCE AND TECHNOLOGY
PHILIPPINE NUCLEAR RESEARCH INSTITUTE
COMMONWEALTH AVENUE, DILMAN, QUEZON CITY

PROJECT:	SHEET CONTENT:	PREPARED BY:	RECOMMENDING APPROVAL:	APPROVED BY:	DRAWN BY: GENBLAZO	SHEET NO.:
UPGRADING OF N.A.R.T BLDG. (C.Y. 2021)	SECOND FLOOR HALLWAY LIGHTING LAYOUT	Engr. ROSALINDO B. REJAS Senior Science Research Specialist Engr. ARTURO F. SALIH Senior Science Research Specialist Engr. ANDREW C. BARRIDA Engineer I, ESS	GERARDO JOSE M. ROBLES End-User/Client MA. CELERINA M. RAMIRO CHIEF, FAD PRECIOUSA CORAZON B. PABROA, Ph. D. CHIEF, NSD LUCILLE V. ABAD, Ph. D. D.C., Deputy Director	Engr. RENATO T. BAÑAGA ESS Head CARLO J. ARVILLA, Ph. D. Director	CHECKED BY: DATE: JULY 09, 2021 PROJ. NO.:	E-2 PAGE NO.: 21/39

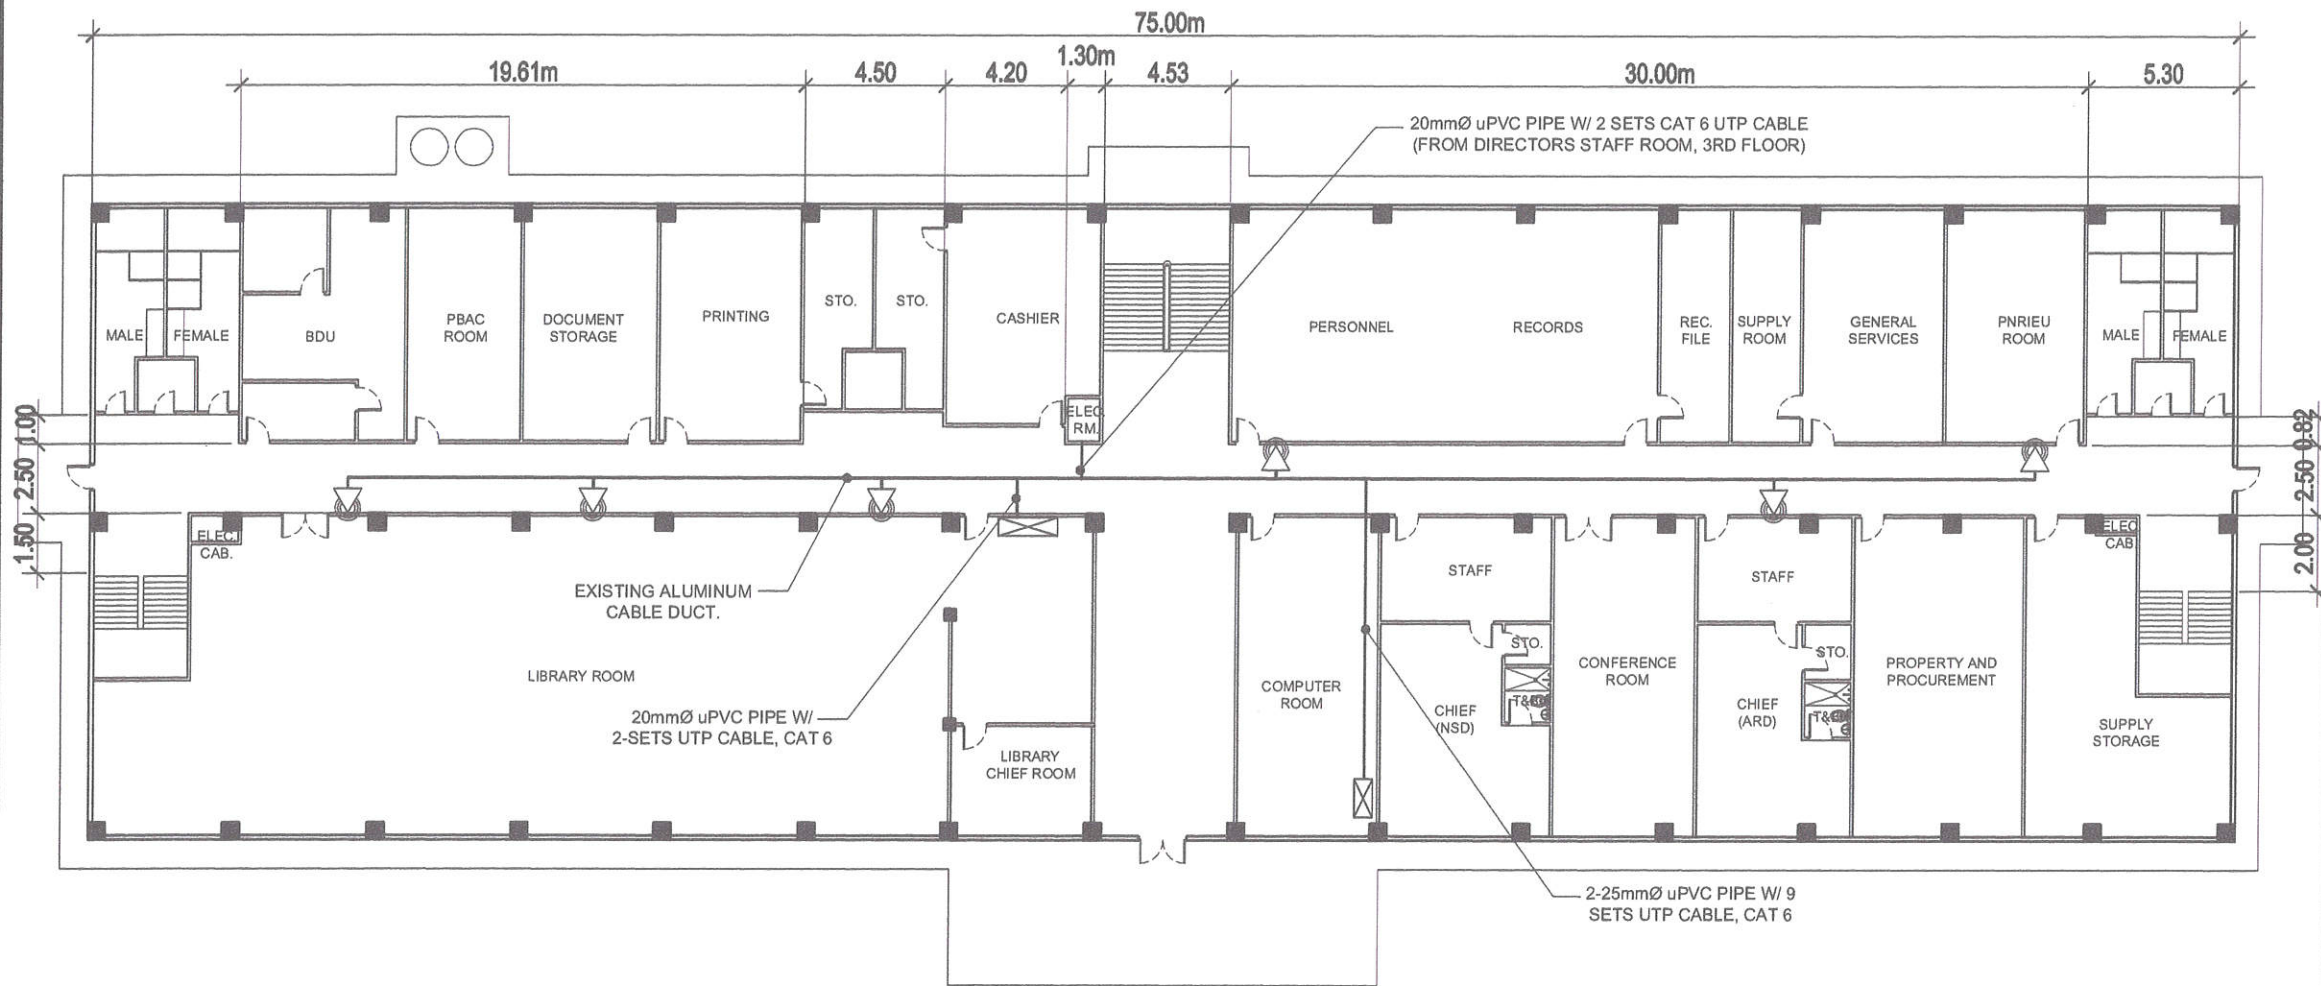

1 SECOND FLOOR PLAN (DATA LAN LAYOUT)
SCALE NTS

LEGEND:

- PROVISION LINES FOR ACCESS POINT
- BLACK BOX



Republic of the Philippines
DEPARTMENT OF SCIENCE AND TECHNOLOGY
PHILIPPINE NUCLEAR RESEARCH INSTITUTE
COMMONWEALTH AVENUE, DILMAN, QUEZON CITY

PROJECT
UPGRADING OF N.A.R.T BLDG.
(C.Y. 2021)

SHEET CONTENT:
SECOND FLOOR PLAN -
DATA LAN LAYOUT


PREPARED BY:
Engr. ROSALIND B. REJAS
Senior Science Research Specialist
Engr. ARTURO F. SALIH
Senior Science Research Specialist
Engr. ANDREW C. BARRIDA
Engineer I, ESS

RECOMMENDING APPROVAL:
GERARDO JOSE M. ROBLES
Engr. Head, ESS
MA. CELERINA M. RAMIRO
CHIEF, PAD
PRECILSA CORAZON B. PABROA Ph.D.
Chief, NSD
LUCILLE Y. ABAD, Ph.D.
OIC, Deputy Director

APPROVED BY:
CARLO A. ANILLA Ph.D.
Director


DRAWN BY: GENBLAZO
CHECKED BY:
DATE: JULY 09, 2021
PAGE NO.:
22/39

SHEET NO.:
E-3

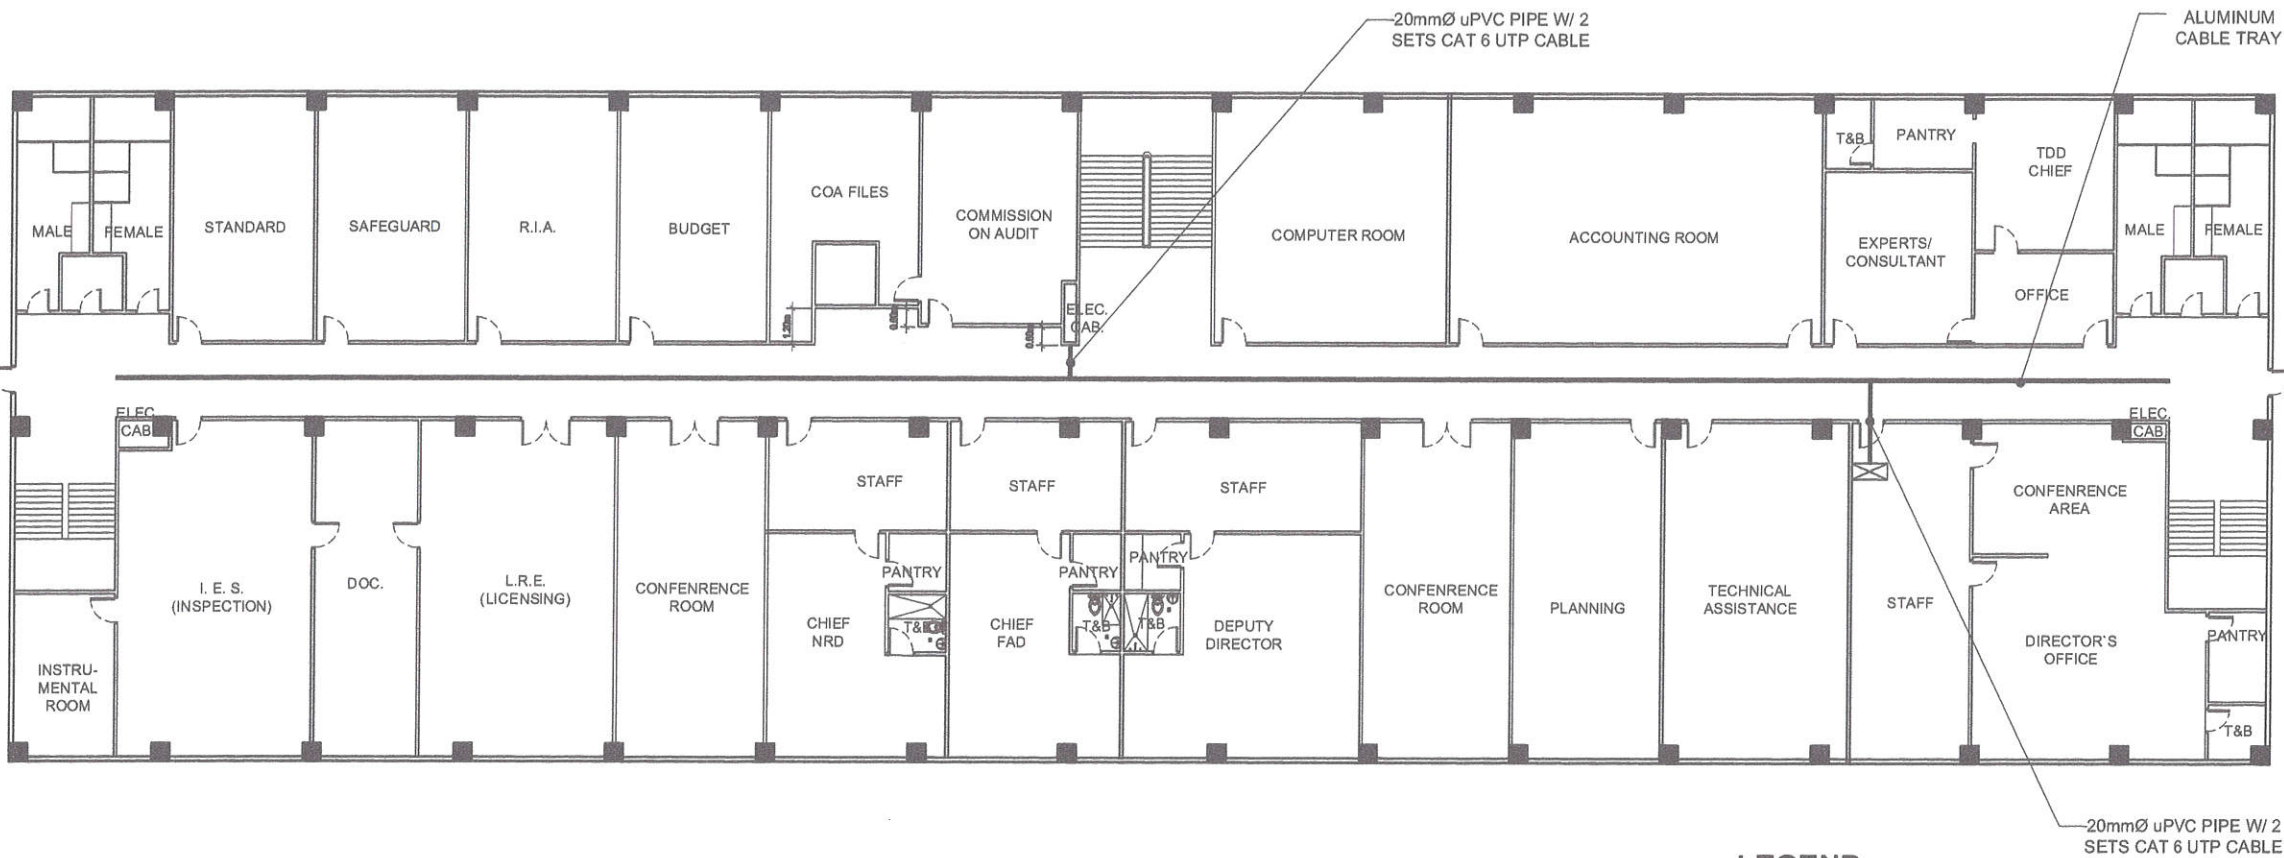

1 THIRD FLOOR PLAN (DATA LAN LAYOUT)
SCALE _____ NTS

LEGEND:
 - BLACK BOX

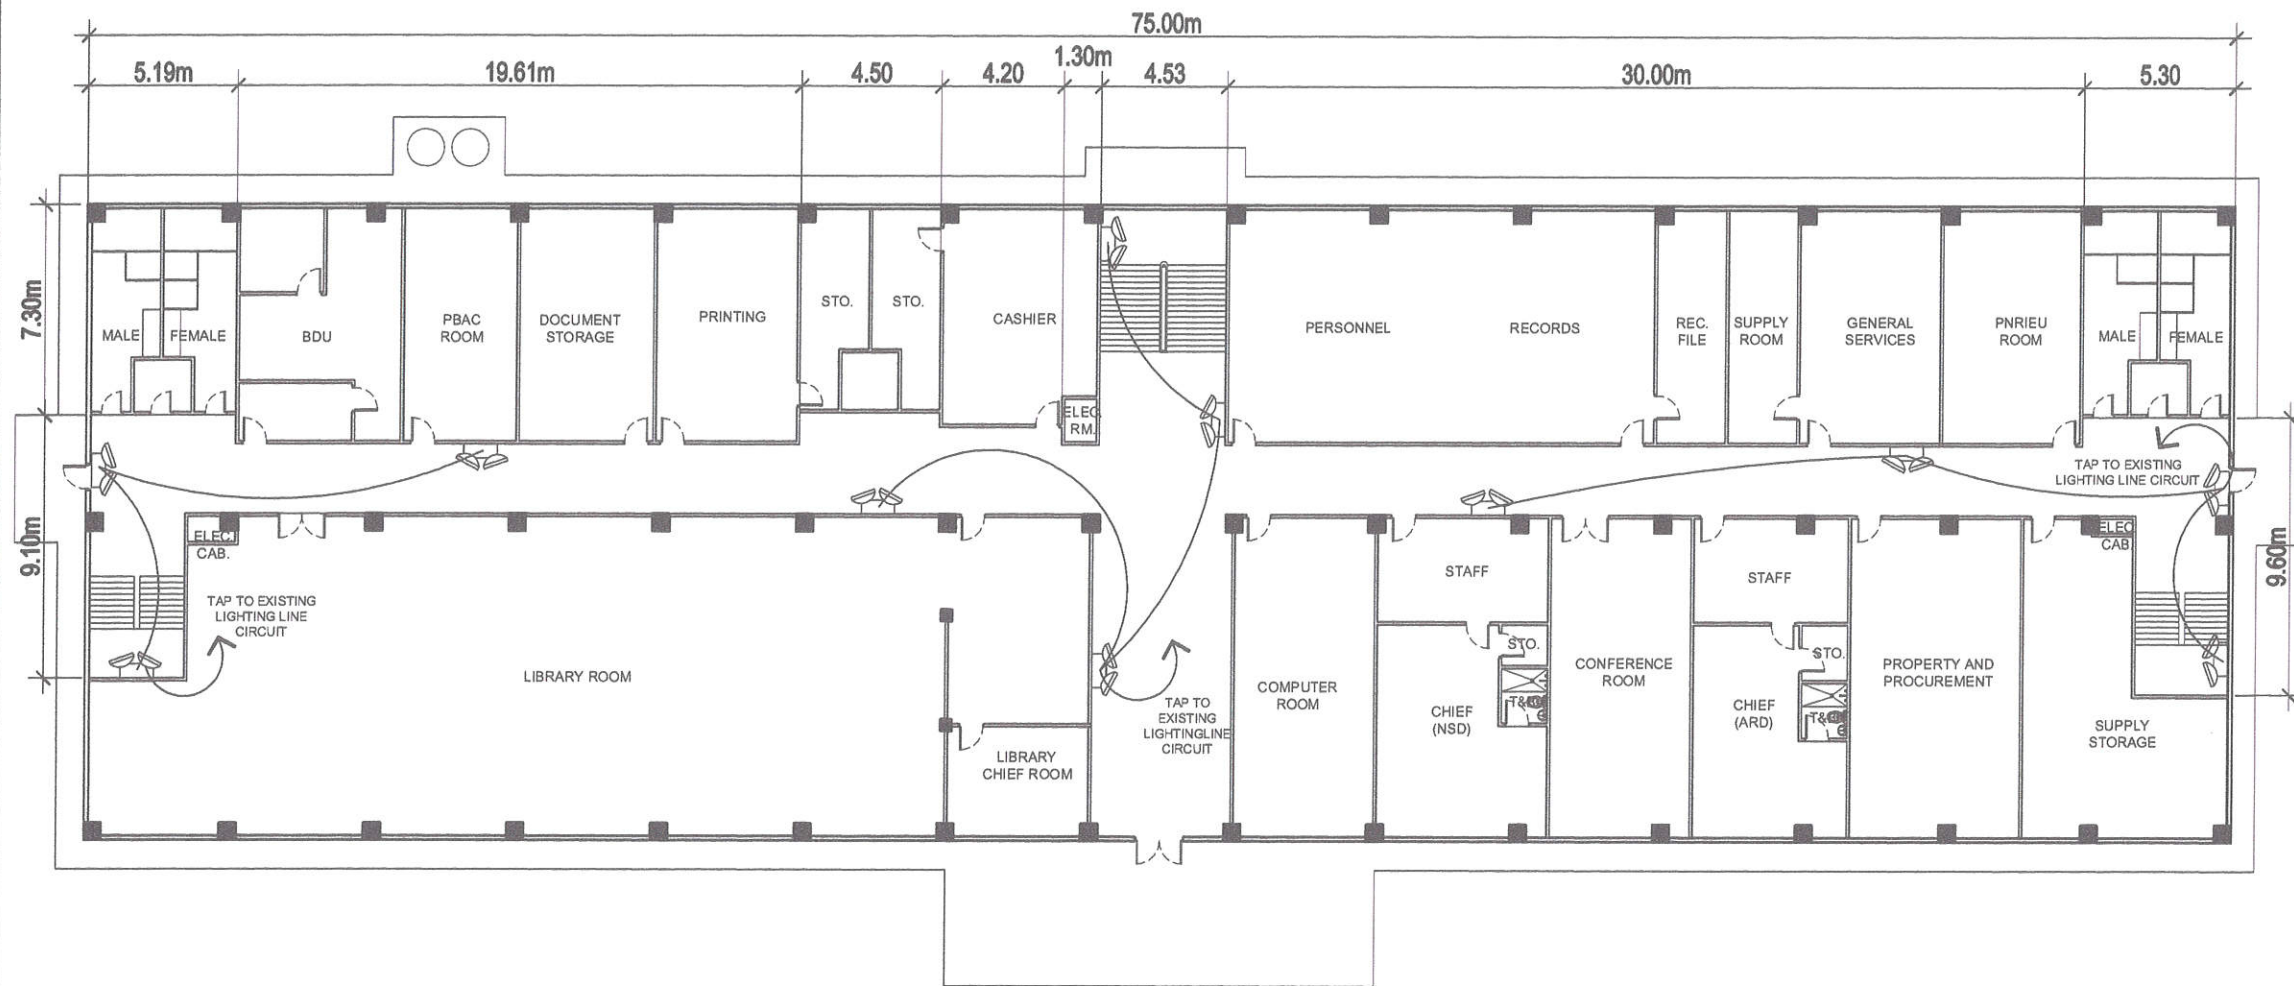

1 SECOND FLOOR PLAN - EMERGENCY LIGHT LAYOUT
SCALE NTS


LEGEND:

 - EMERGENCY LIGHT




Republic of the Philippines
DEPARTMENT OF SCIENCE AND TECHNOLOGY
PHILIPPINE NUCLEAR RESEARCH INSTITUTE
COMMONWEALTH AVENUE, DILIMAN, QUEZON CITY

PROJECT:	SHEET CONTENT:	PREPARED BY:	RECOMMENDING APPROVAL:	APPROVED BY:	DRAWN BY: GENBLAZO	SHEET NO.:
UPGRADING OF N.A.R.T BLDG. (C.Y. 2021)	SECOND FLOOR PLAN - EMERGENCY LIGHT LAYOUT	Engr. ROSALINO B. REJAS Senior Science Research Specialist Engr. ARTURO F. SALIN Senior Science Research Specialist Engr. ANDREW C. BARRIDA Engineer I, ESS	GERARDO JOSE M. ROBLES Engr. User Head GSS MA. CELERINA M. RAMIRO CHIEF, PAD PRECILISA GARCIA ZON B. PABROA Ph. D. Chief, NSD LUCILLE Y. ABAD, Ph. D. CIC, Deputy Director	Engr. RENATO T. BANAAGA ESS Head CARLO A. BUSTILLA Ph. D. Director	CHECKED BY: DATE: JULY 09, 2021 PROJ. NO.:	E-5 PAGE NO.: 24/39

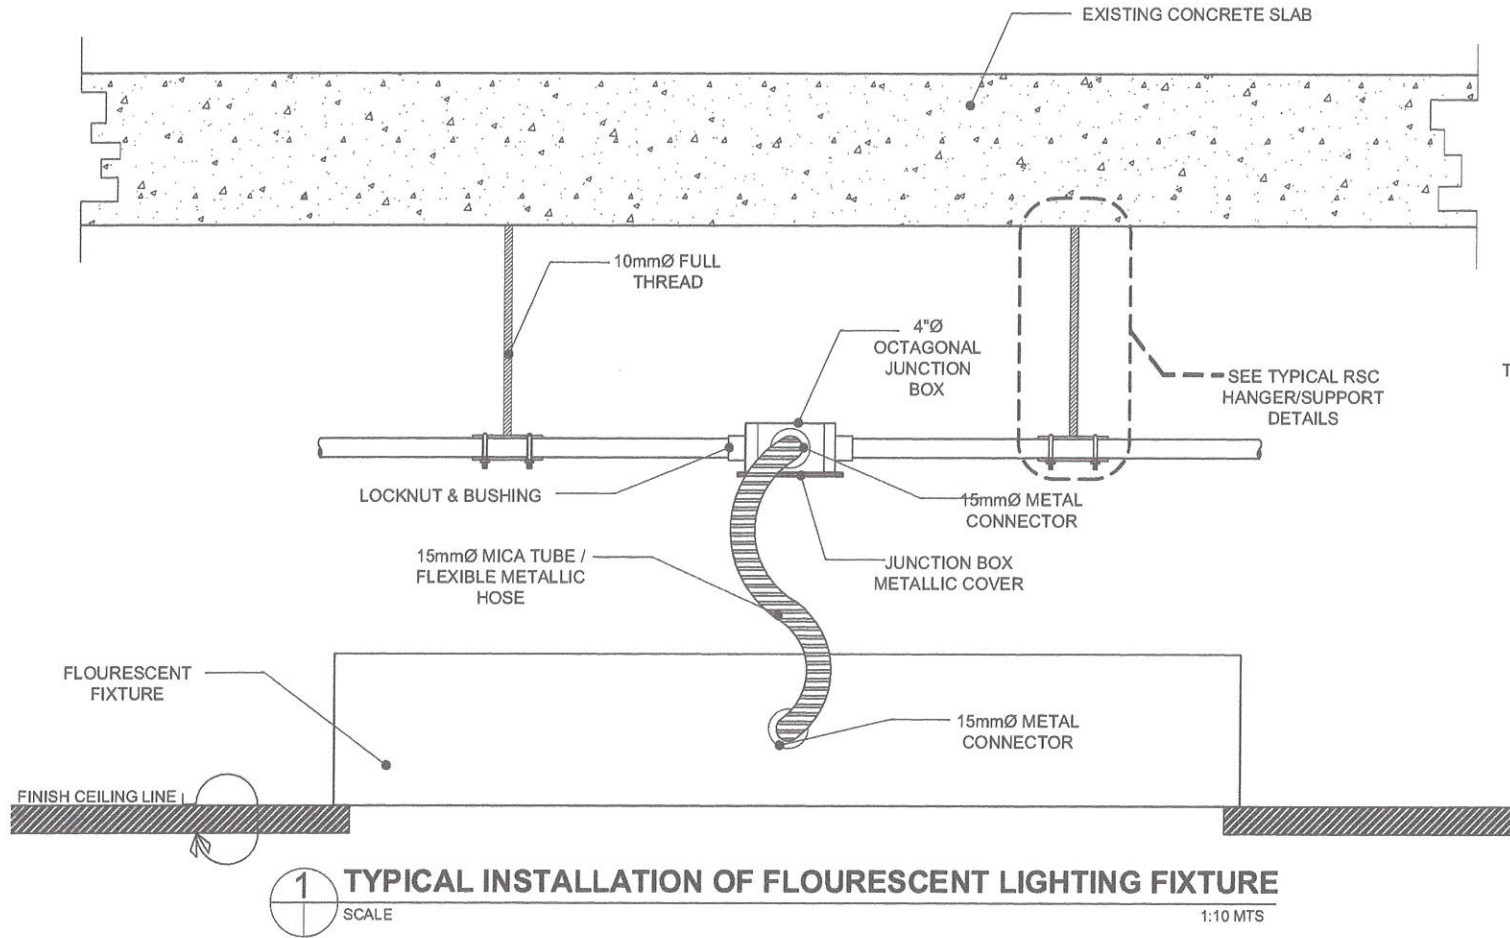

1 TYPICAL INSTALLATION OF FLOURESCENT LIGHTING FIXTURE

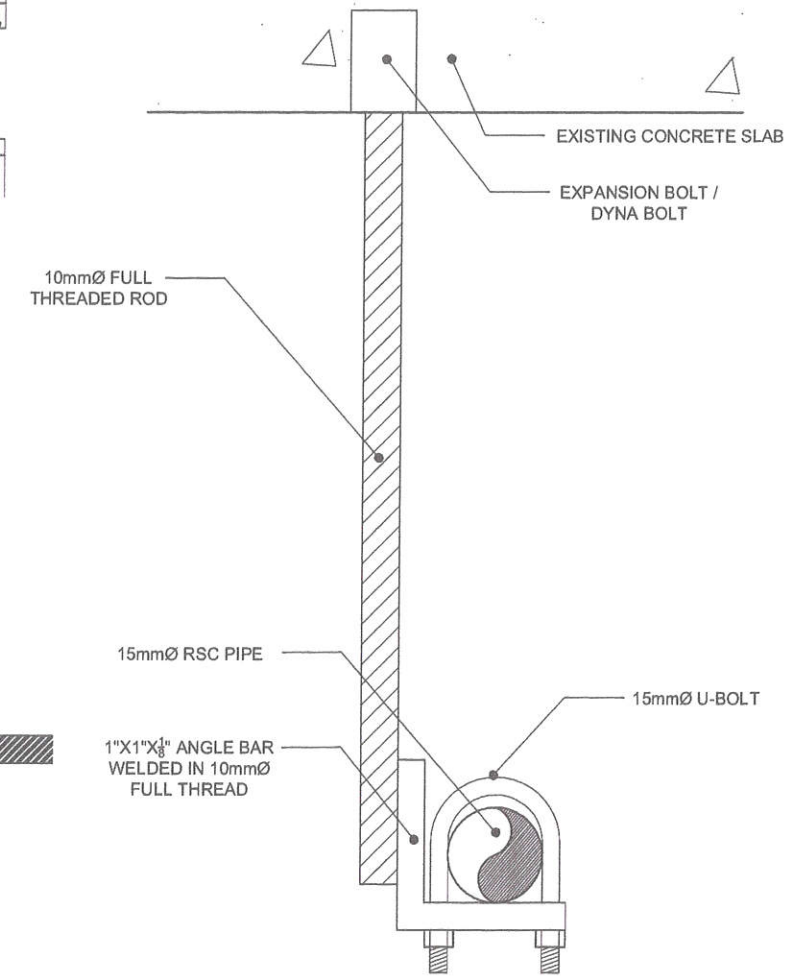


2 TYPICAL RSC HANGER/SUPPORT



Republic of the Philippines
DEPARTMENT OF SCIENCE AND TECHNOLOGY
PHILIPPINE NUCLEAR RESEARCH INSTITUTE
 COMMONWEALTH AVENUE, DILMAN, QUEZON CITY


PROJECT:	SHEET CONTENT:	PREPARED BY:	RECOMMENDING APPROVAL:	APPROVED BY:	DRAWN BY: GENBLAZO	SHEET NO.:
UPGRADING OF N.A.R.T BLDG. (C.Y. 2021)	DETAILS INSTALLATION OF FLOURESCENT FIXTURES & RSC HANGER SUPPORT	Engr. ROSALYN B. REJAS Senior Science Research Specialist Engr. ARTURO F. SALIH Senior Science Research Specialist Engr. ANDREW C. BARRIDA Engineer I ESS	GERARDO JOSE M. ROBLES End-User Head GSS MA. CELERINA M. RAMROS CHIEF, FAD PRECIOSA CORAZON B. PABROA Ph.D. Chief, NSO	Engr. RENATO T. BANAGA Senior Head CARLO A. ARCILLAS Ph.D. Director	CHECKED BY: DATE: JULY 09, 2021 PROJ. NO.:	E-6 PAGE NO.: 25/39

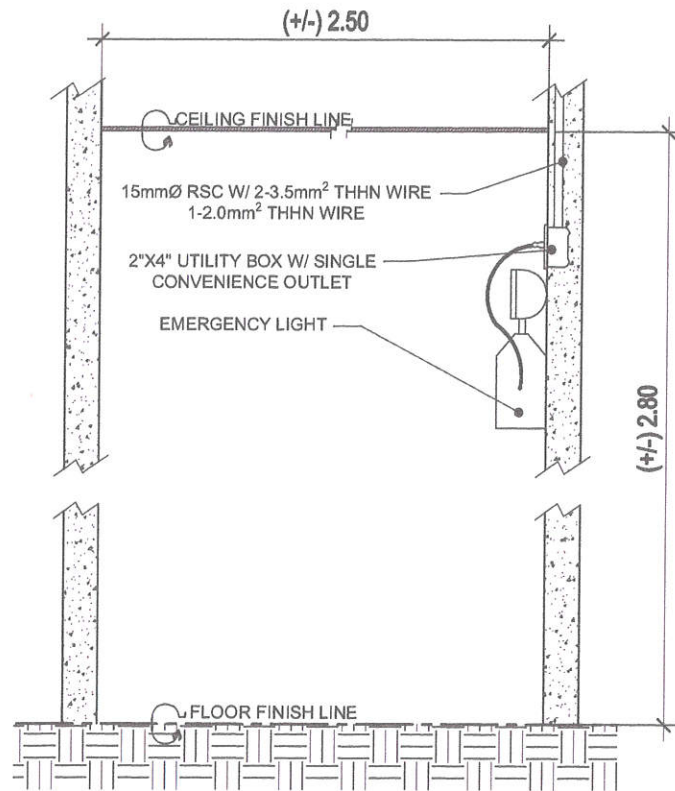

1
SCALE

TYPICAL INSTALLATION OF EMERGENCY LIGHT

NTS

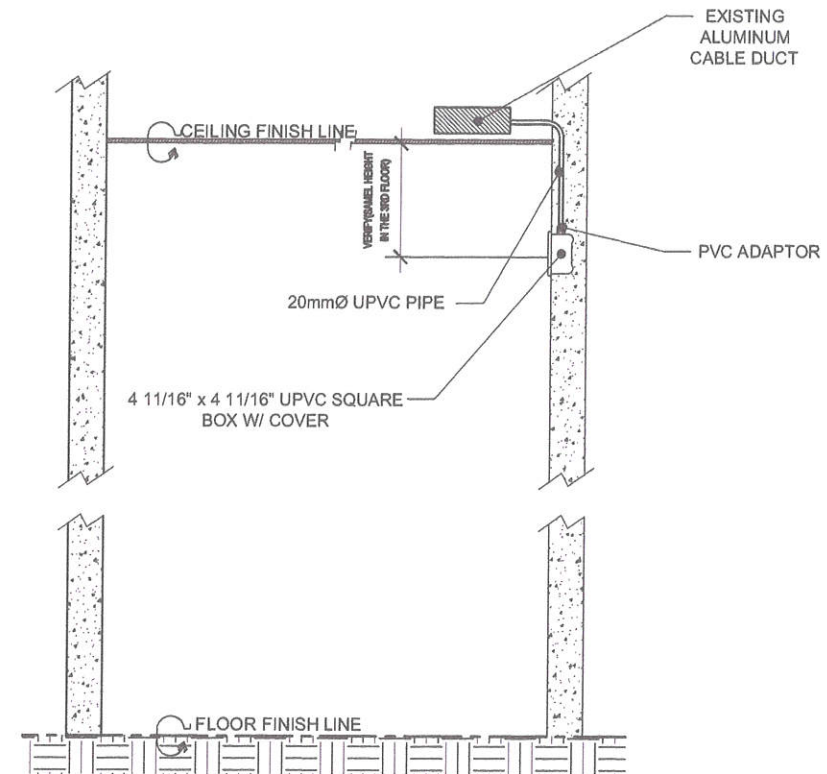

1
SCALE


TYPICAL INSTALLATION FOR LAN ACCESS POINT

NTS




Republic of the Philippines
DEPARTMENT OF SCIENCE AND TECHNOLOGY
PHILIPPINE NUCLEAR RESEARCH INSTITUTE
COMMONWEALTH AVENUE, DILMAN, QUEZON CITY

PROJECT:	SHEET CONTENT:	PREPARED BY:	RECOMMENDING APPROVAL:	APPROVED BY:	DRAWN BY: GENBLAZO	CHECKED BY:	DATE: JULY 09, 2021	PAGE NO.: 26/39
UPGRADING OF N.A.R.T BLDG. (C.Y. 2021)	SECOND FLOOR EMERGENCY LIGHT LAYOUT	Engr. ROSALYN B. REJAS Senior Science Research Specialist Engr. ARTURO F. SALIH Senior Science Research Specialist Engr. ANDREW C. BARRIDA Engineer I ESS	GERARDO JOSE M. ROBLES End-User, Head ESS MA. CELERINA M. RAMIRO CHIEF, FAD PRECIOSA FORAZON B. PABROA, Ph.D. Chief, NSO LUCILLE Y. ABAD, Ph.D. OIC, Deputy Director	CARLO A. ARULLA, Ph.D. Director				

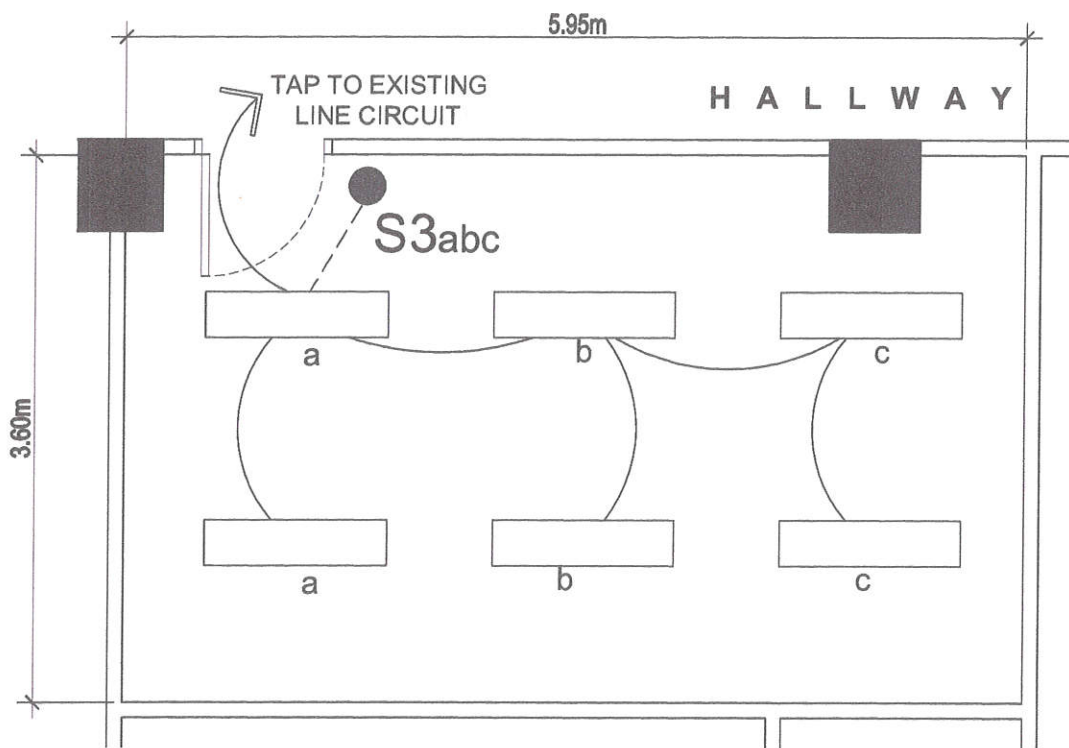

NSD OFFICE STAFF

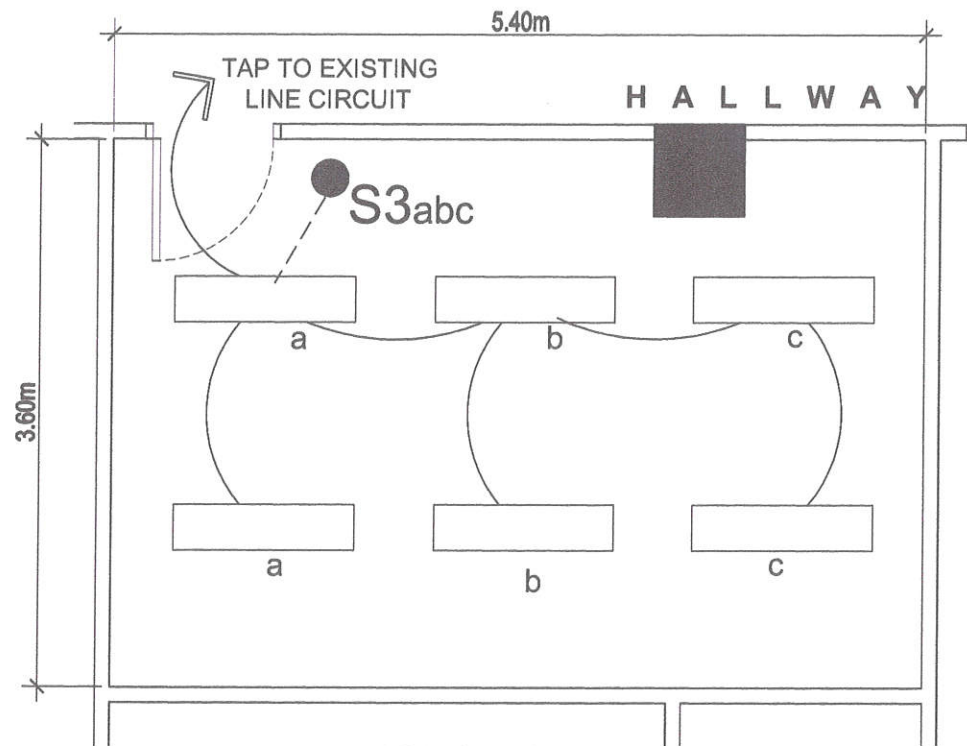

ARD OFFICE STAFF

1 SECOND FLOOR - LIGHTING LAYOUT
SCALE NTS



Republic of the Philippines
DEPARTMENT OF SCIENCE AND TECHNOLOGY
PHILIPPINE NUCLEAR RESEARCH INSTITUTE
COMMONWEALTH AVENUE, OLMAN, QUEZON CITY

PROJECT:
UPGRADING OF N.A.R.T BLDG.
(C.Y. 2021)

SHEET CONTENT:
SECOND FLOOR -
LIGHTING LAYOUT

PREPARED BY:
Engr. ROSALINO B. REJAS
Senior Science Research Specialist
Engr. ARTURO F. SAH
Senior Science Research Specialist
Engr. ANDREW C. BARRIDA
Engineer I, EBS

RECOMMENDING APPROVAL:
GERARDO JOSE M. ROBLES
Engr. Head GBS
MA. CELERINA M. RAMIRO
CHIEF, PAD
PRECIOSA DOMAZON B. PABROA, Ph.D.
Chief, NSD
LUCILLE Y. ABAD, Ph.D.
OIC, Deputy Director

APPROVED BY:
CARLO A. ORILLA, Ph.D.
Director

DRAWN BY: GENBLAZO
CHECKED BY:
DATE: JULY 09, 2021
PROJ. NO.:
SHEET NO.:
E-8
PAGE NO.:
27/39