



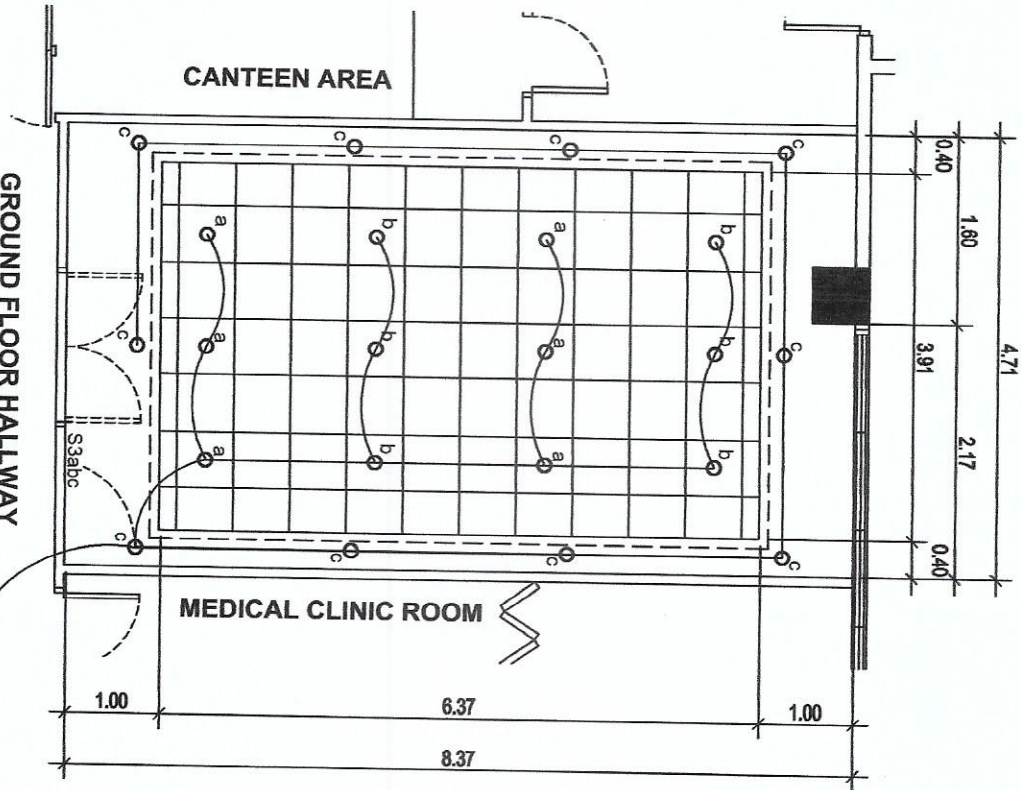

1
SCALE
NART BLDG. - GROUND FLOOR
MKLACC OFFICE PLAN
NTS

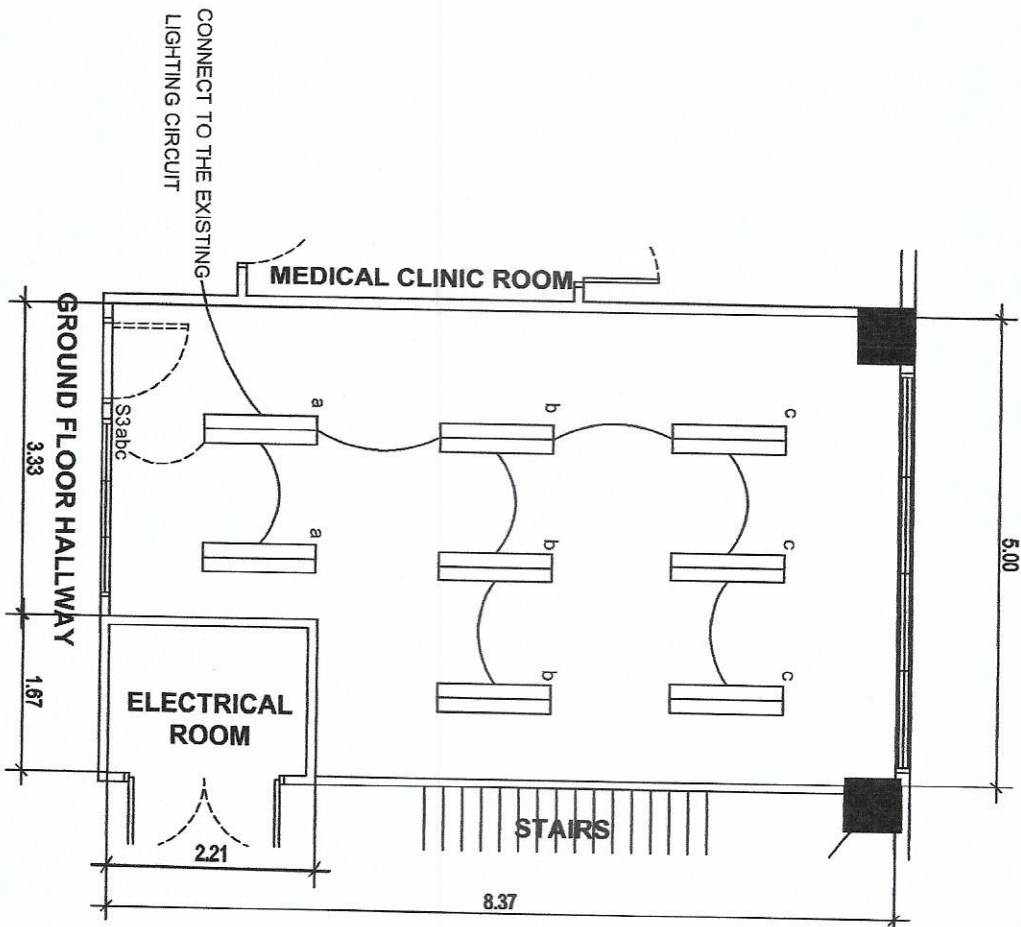

1
SCALE
NART BLDG. - GROUND FLOOR
NUCLEAR INFORMATION AND DOCUMENTATION
NTS



Republic of the Philippines
DEPARTMENT OF SCIENCE AND TECHNOLOGY
PHILIPPINES NUCLEAR RESEARCH INSTITUTE
COMMODITY AVENUE, DILIMAN, CEBU CITY

UPGRADING OF
NART BLDG. 2023

NART BLDG.
GROUND FLOOR - ELECTRICAL
LIGHTING LAYOUT


ENGR. ROSALYN B. REYES
Senior Science Officer
ENGR. ANDREW C. BARRERA
Engr. III

GERARDO J. ROSALES
Engr. III
ENGR. ARMANDO F. SAEH
Engr. III
PRECIOUSA FORAZON B. PABROA, Ph.D.
Engr. III
VALERIE ANN SAMSON, Ph.D.
Engr. III

ENGR. CARLO A. ARCELLANO, D.
Engr. III

DRAWN BY:
CHECKED BY:
DATE:

SHEET NO.
E-1
PAGE NO.:

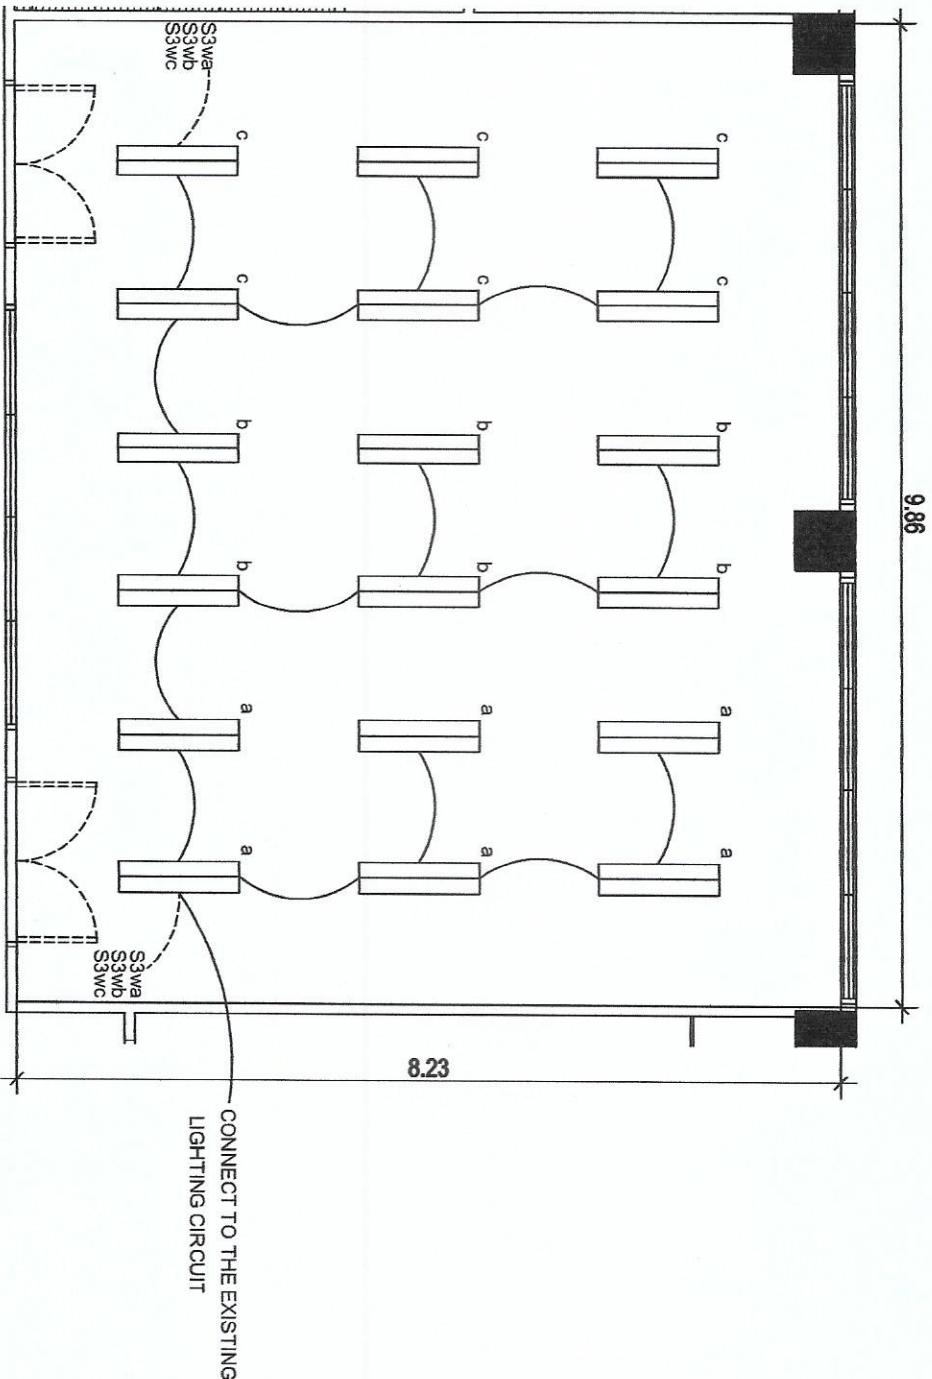


1 NART BLDG. - GROUND FLOOR
NUCLEAR TRAINING CENTER OFFICE AREA
SCALE NTS




Republic of the Philippines
DEPARTMENT OF SCIENCE AND TECHNOLOGY
PHILIPPINES NUCLEAR RESEARCH INSTITUTE
CRIMINAL JUSTICE DIVISION, DILIGENT CITY

PROJECT	SHEET CONTENT	PREPARED BY	REVIEWED BY	APPROVED BY	DRAWN BY	SHEET NO.
UPGRADING OF NART BLDG. 2023	NART BLDG. GROUND FLOOR - ELECTRICAL LIGHTING LAYOUT	Engr. ROSALYN B. REYES Engr. ANDREW C. BARRERA Engr. 1123	GERARDO JOSE M. ROBLES Engr. 1123 Engr. ARTURO F. SALIH Engr. 1123 Engr. CARLOS M. RAMO Engr. 1123 Engr. VALERIE ANN RAMSON, Ph.D. Engr. 1123	Engr. CARLOS M. RAMO Engr. 1123 Engr. VALERIE ANN RAMSON, Ph.D. Engr. 1123	Engr. CARLOS M. RAMO Engr. 1123 Engr. VALERIE ANN RAMSON, Ph.D. Engr. 1123	E-2

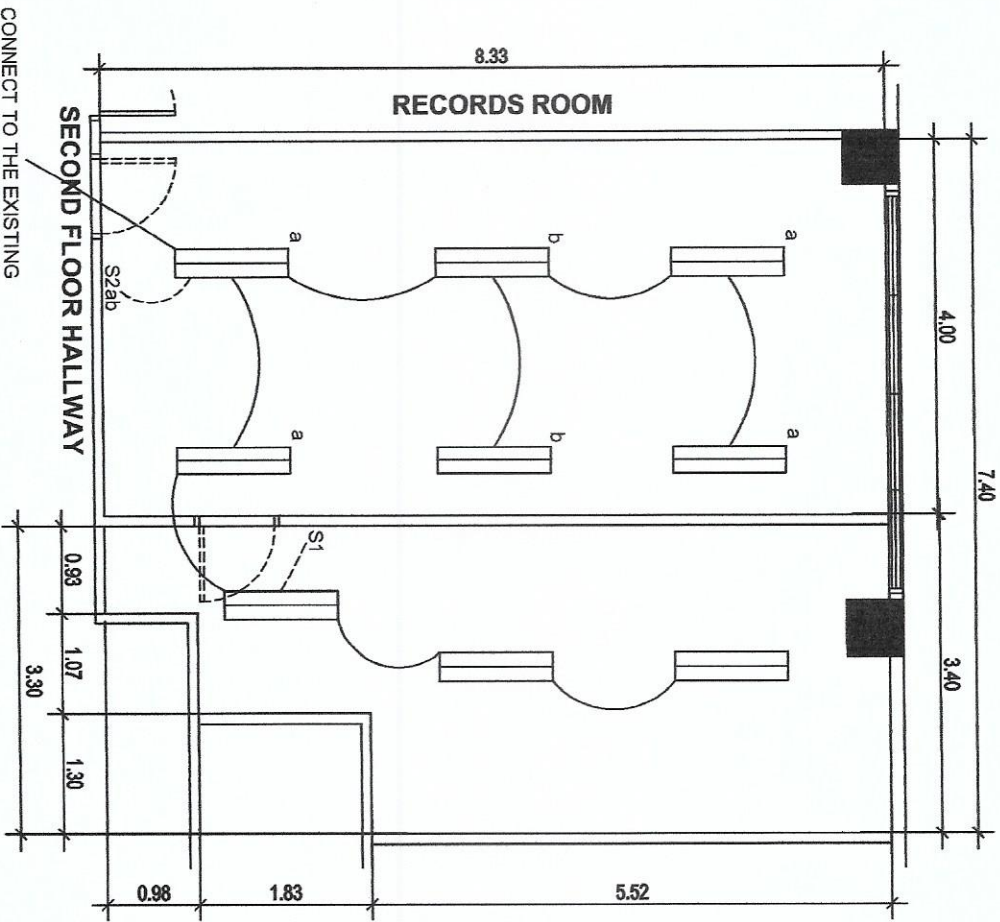

NART BLDG. - SECOND FLOOR
PRINTING ROOM
SCALE 1/100
NTS

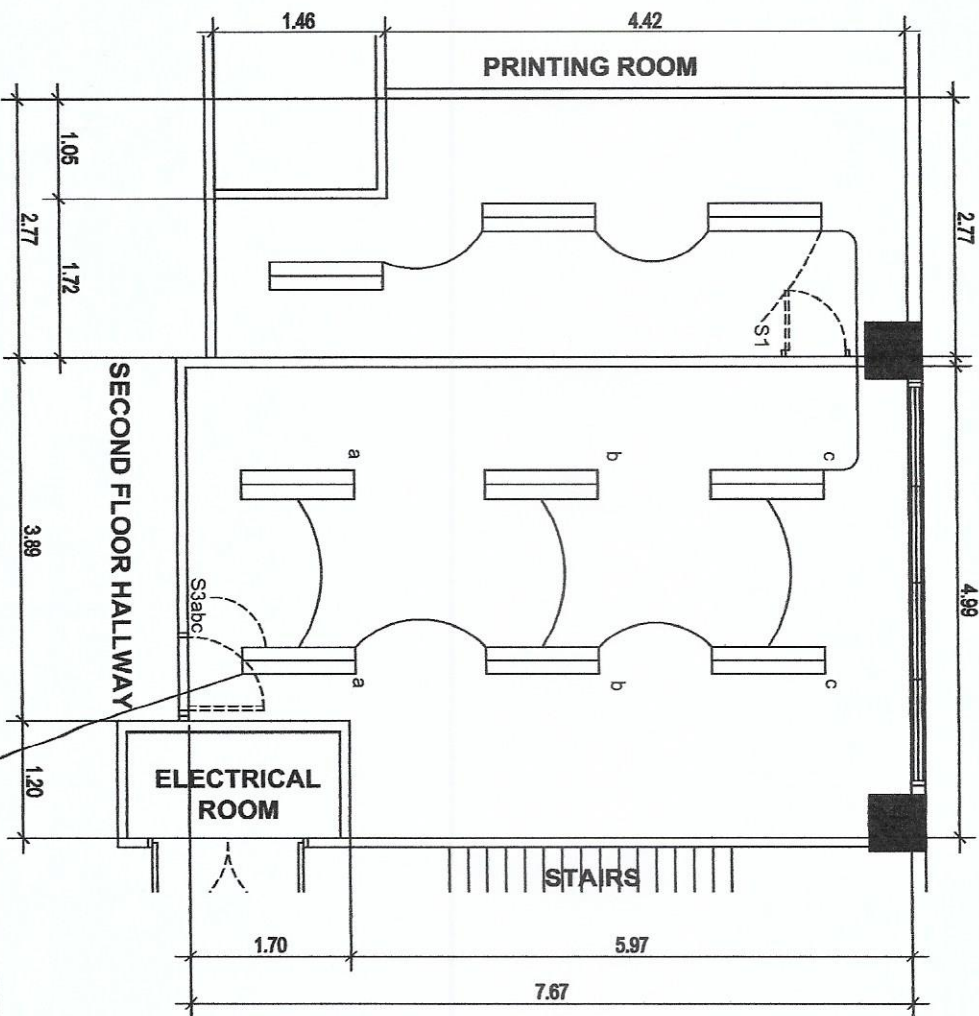

NART BLDG. - SECOND FLOOR
CASHIER OFFICE
SCALE 1/100
NTS



Republic of the Philippines
DEPARTMENT OF SCIENCE AND TECHNOLOGY
PHILIPPINES NUCLEAR RESEARCH INSTITUTE
COMMONWEALTH AVENUE, DILMAN, QUEZON CITY

PROJECT

UPGRADING OF
NART BLDG., 2023

SHEET CONTENT

NART BLDG.
SECOND FLOOR -
ELECTRICAL LIGHTING LAYOUT

PREPARED BY:

Engr. ROSALIND B. REYES
Senior Planning Engineer
Engr. ANDREW C. BARRIOA
Engr. EBB

RECOMMENDED BY:

GERARDO JOSE M. ROBRES
Engr. (Architect) GSB
MA CECILIA M. RAUJO
Chief PWD
PRECOSAMONAZON E. PABROA, Ph.D.
Chief IED

APPROVED BY:

Engr. ARMANDO F. SALIN
O.C. 5818358
CARLA MARICELA M. D.
Director

DRAWN BY:



CHECKED BY:

DATE:

SHEET NO.:

E-3

PLATE NO.:

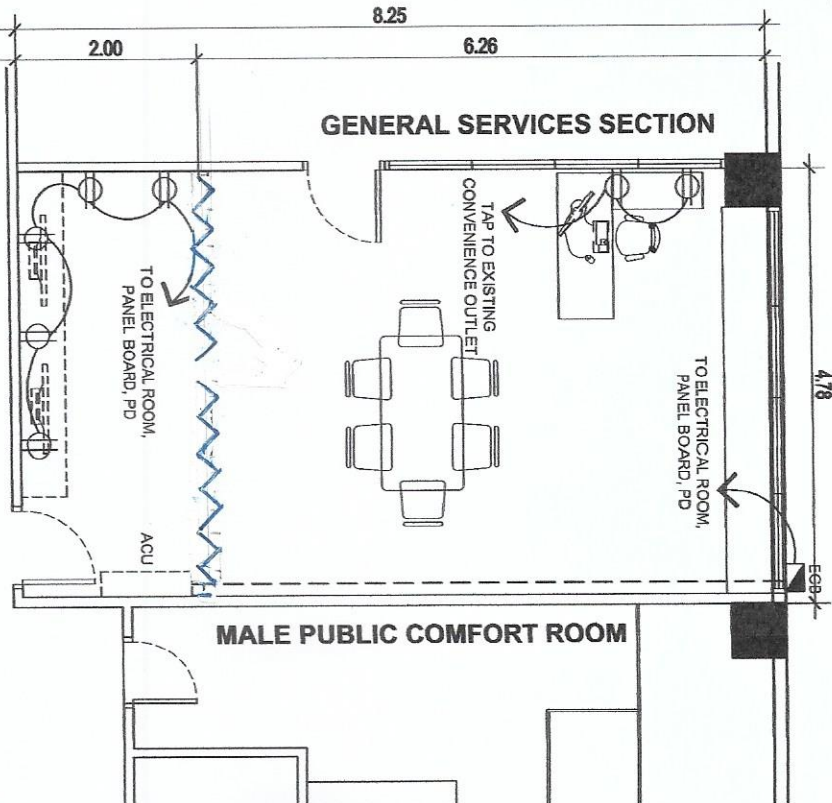
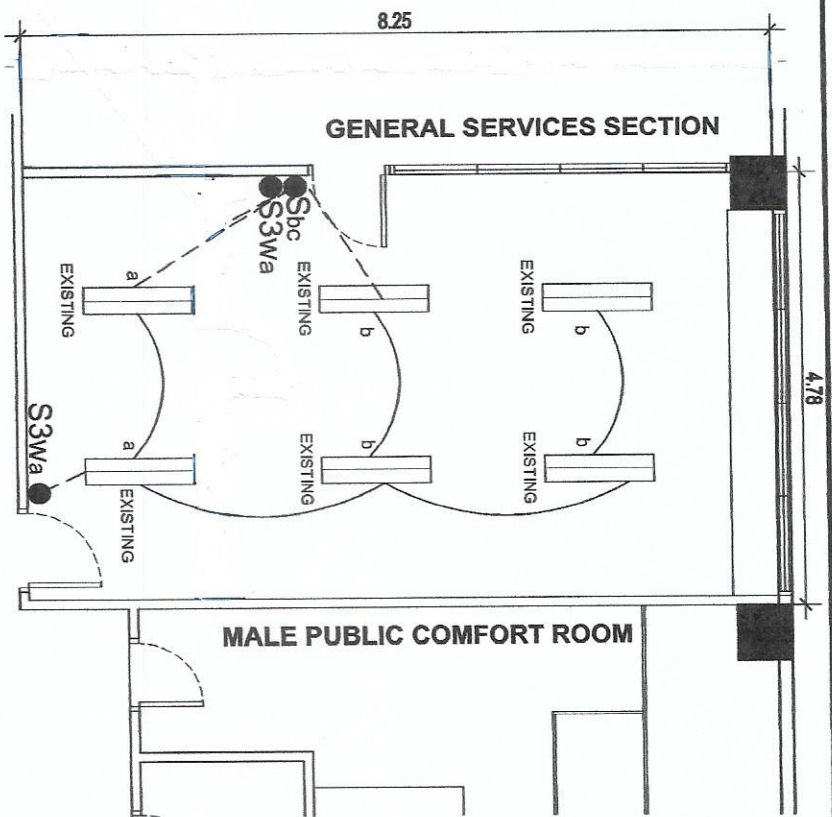


SECOND FLOOR HALLWAY


SECOND FLOOR HALLWAY

NOTE:

REWIRING OF SIX (6) SETS OF FLUORESCENT FIXTURES
LIGHTING CIRCUITS W/ TWO (2) SETS LIGHTING SWITCHES
AS INDICATED INTO ELECTRICAL LAYOUT

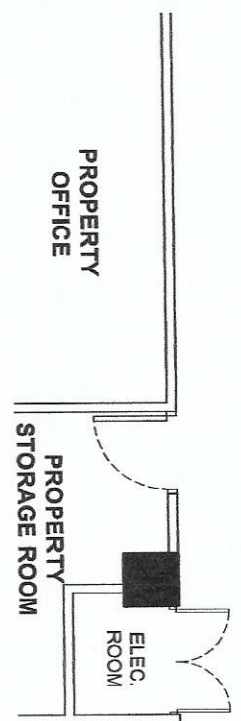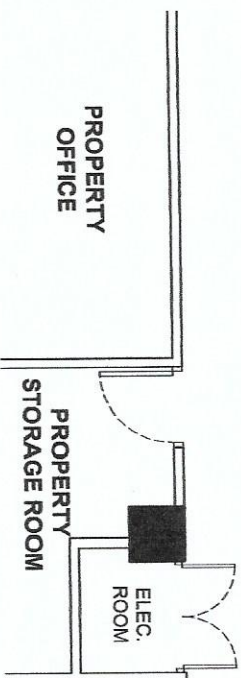

 NART BLDG. - SECOND FLOOR LIGHTING LAYOUT



NART BLDG. - SECOND FLOOR POWER LAYOUT



- LEGEND:**
- ENCLOSED CIRCUIT BREAKER
 - 2-GANG SWITCH
 - 3-WAY SWITCH
 - WALL EXHAUST FAN
 - CONVENIENCE OUTLET
 - ACU

- 2S_{ab}
- S3W_{abc}



Republic of the Philippines
DEPARTMENT OF SCIENCE AND TECHNOLOGY
PHILIPPINES NUCLEAR RESEARCH INSTITUTE
3680 MARINA VIEW AVENUE, ALABANG, MARIKINA CITY

UPGRADING OF BDS OFFICE
- NART BUILDING - 2023

RENOVATION OF 2ND FLOOR
NART BLDG. - PNIU
ROOM, ELECTRICAL LAYOUT

Engr. ROSALIND B. REYES
Senior Research Engineer
Engr. ANDREW BARRERA
Senior Research Engineer

GERARDO JOSE M. ROQUEZ
Senior Research Engineer
DR. GELERITA M. TAMBO
Chief, PNIU
PRECOSA GORDON B. BARROA, Ph.D.
Chief, PNIU
VALERIE ANN KAMSON, Ph.D.
Senior Research Engineer

CARLO A. ARCELES, Ph.D.
Director

DRAWN BY: GENILAB20

CHECKED BY:

DATE:

PROJ. NO.:

SHEET NO.

PAGE NO.

E-5

UPGRADING OF
NART BLDG. 2023

NART BLDG.
THIRD FLOOR -
ELECTRICAL LIGHTING LAYOUT

Engr. ROSALINO B. RELAS
Senior Science Research Specialist
Engr. ANDREW C. BARRIDA


GERARDO JOSÉ M. ROBLES
Edu/Edu 1, Head QSS
MA CB

Eng. ARTURO F. SALIH
DIA. SGRS EMB
RAMIRO
VALERIE ANN SAMSON, Ph. D.
General Director

CARLO A. ARCILLA, Ph. D.
Director

CHECKED BY	
DATE:	

PAGE NO. : E-6

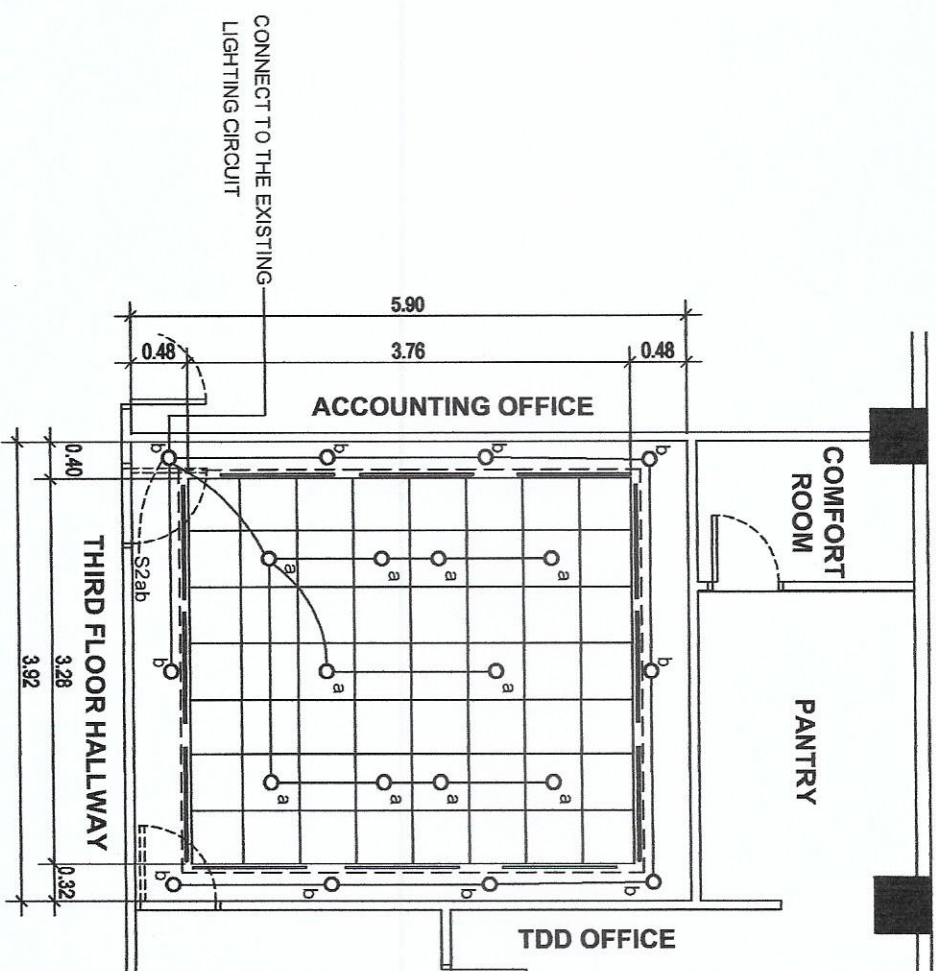

**NART BLDG. - THIRD FLOOR
EXPERTS/CONSULTANT ROOM**

SCALE

NTS